



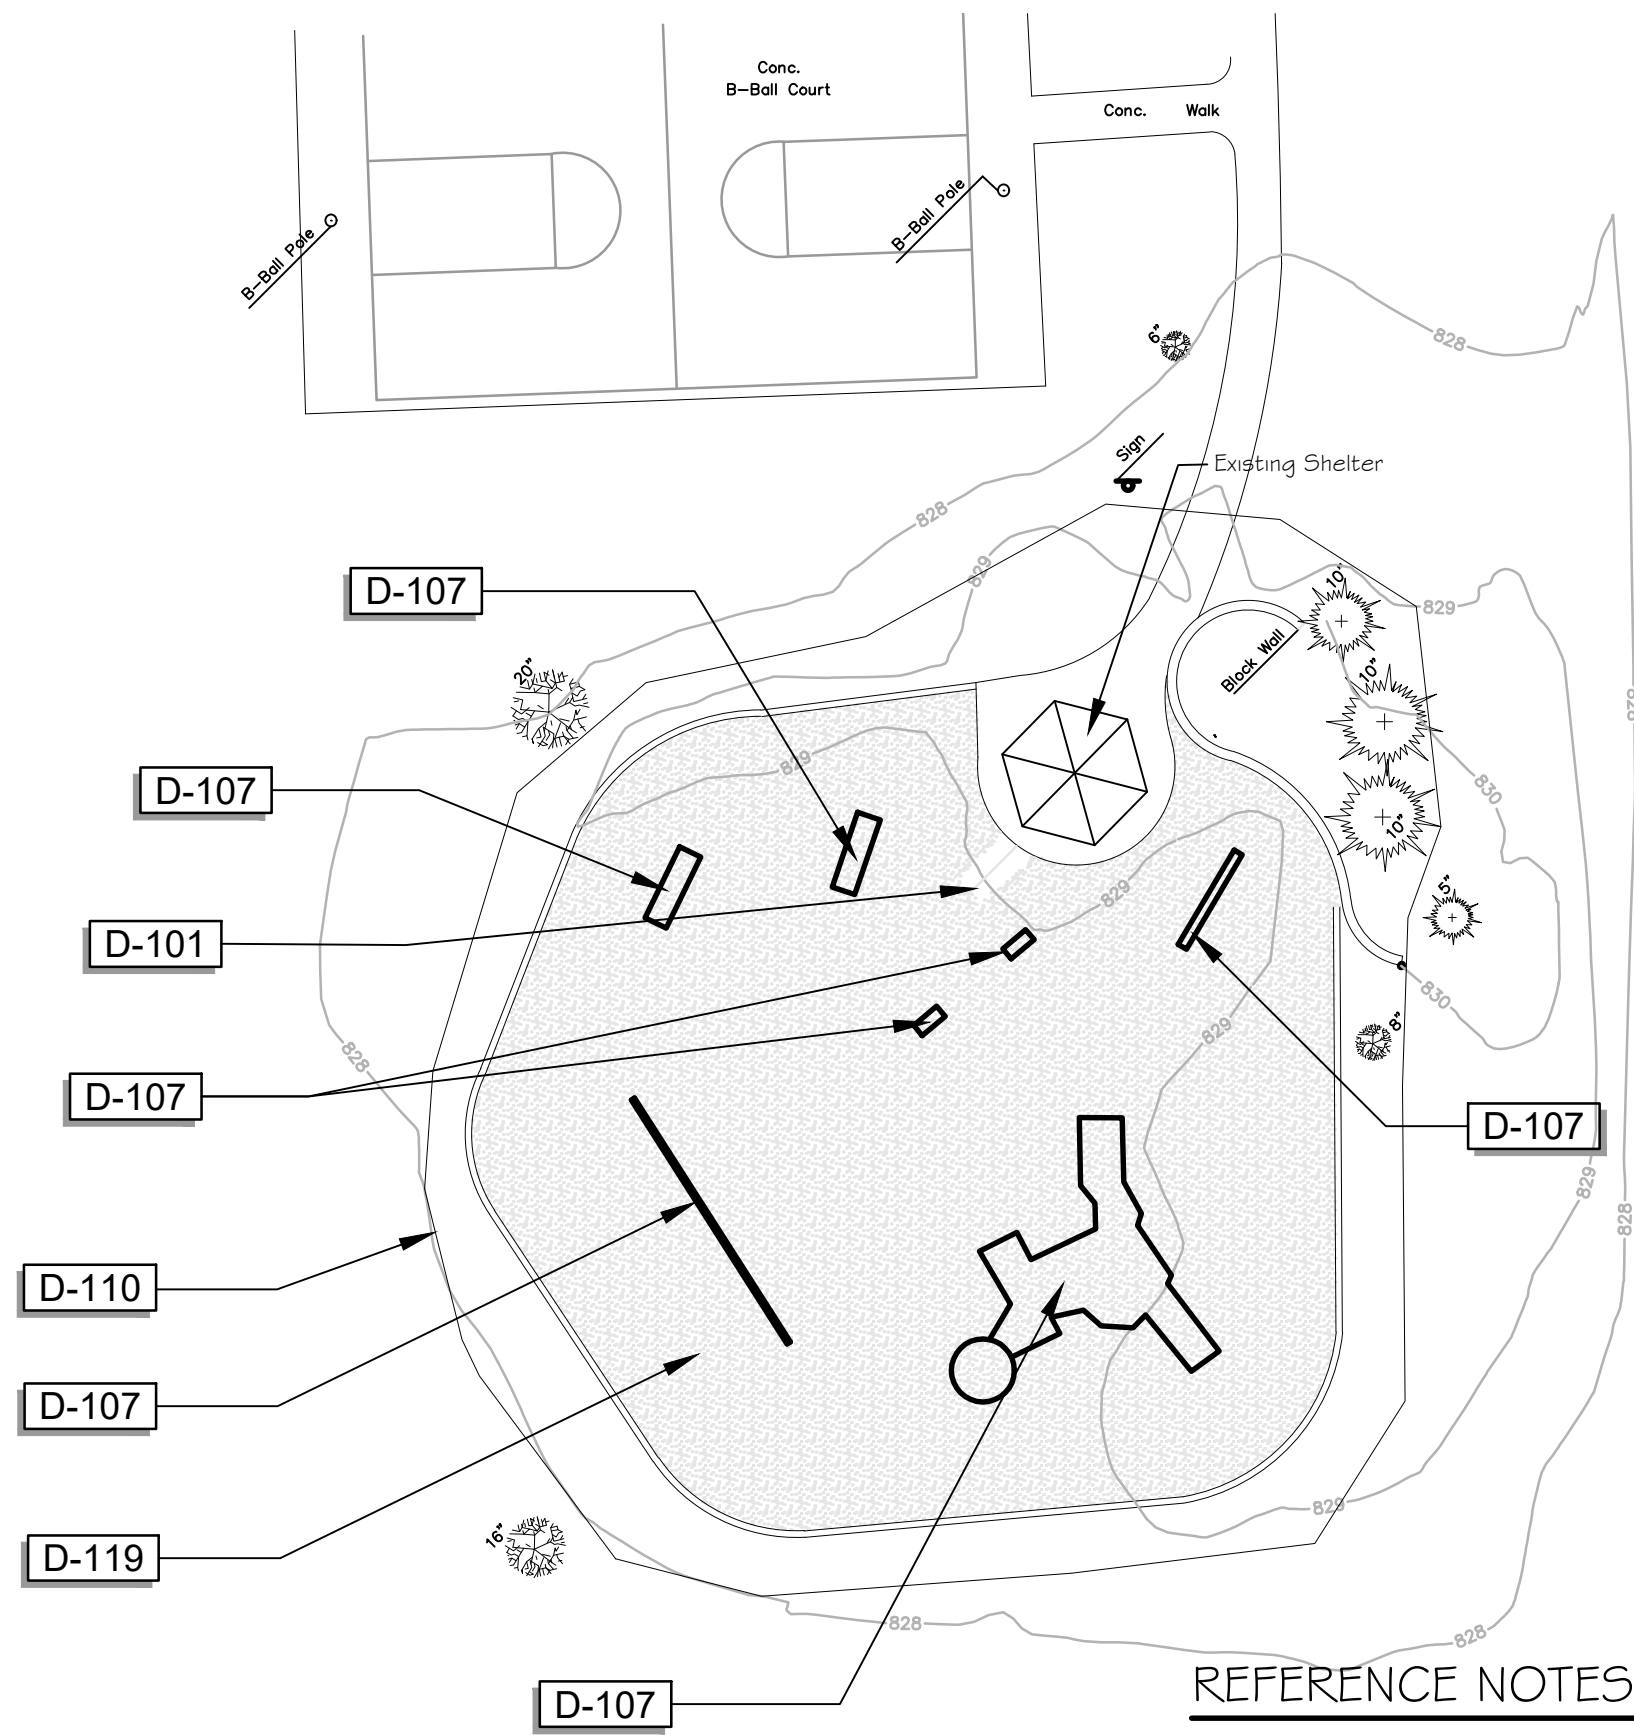

REFERENCE NOTES SCHEDULE WILLOW DEMO

SYMBOL	DEMOLITION DESCRIPTION	QTY	DETAIL
D-101	REMOVE EXISTING CONCRETE FLATWORK	33 SF	
D-107	REMOVE EXISTING PLAYGROUND EQUIPMENT		
D-110	INSTALL AND MAINTAIN PROTECTION FENCE	366 LF	
D-119	REMOVE EXISTING LOOSE FILL WOOD FIBER	230.49 CY	


WILLOW PARK PLAYGROUND DEMO PLAN
SCALE 1" = 20 FT

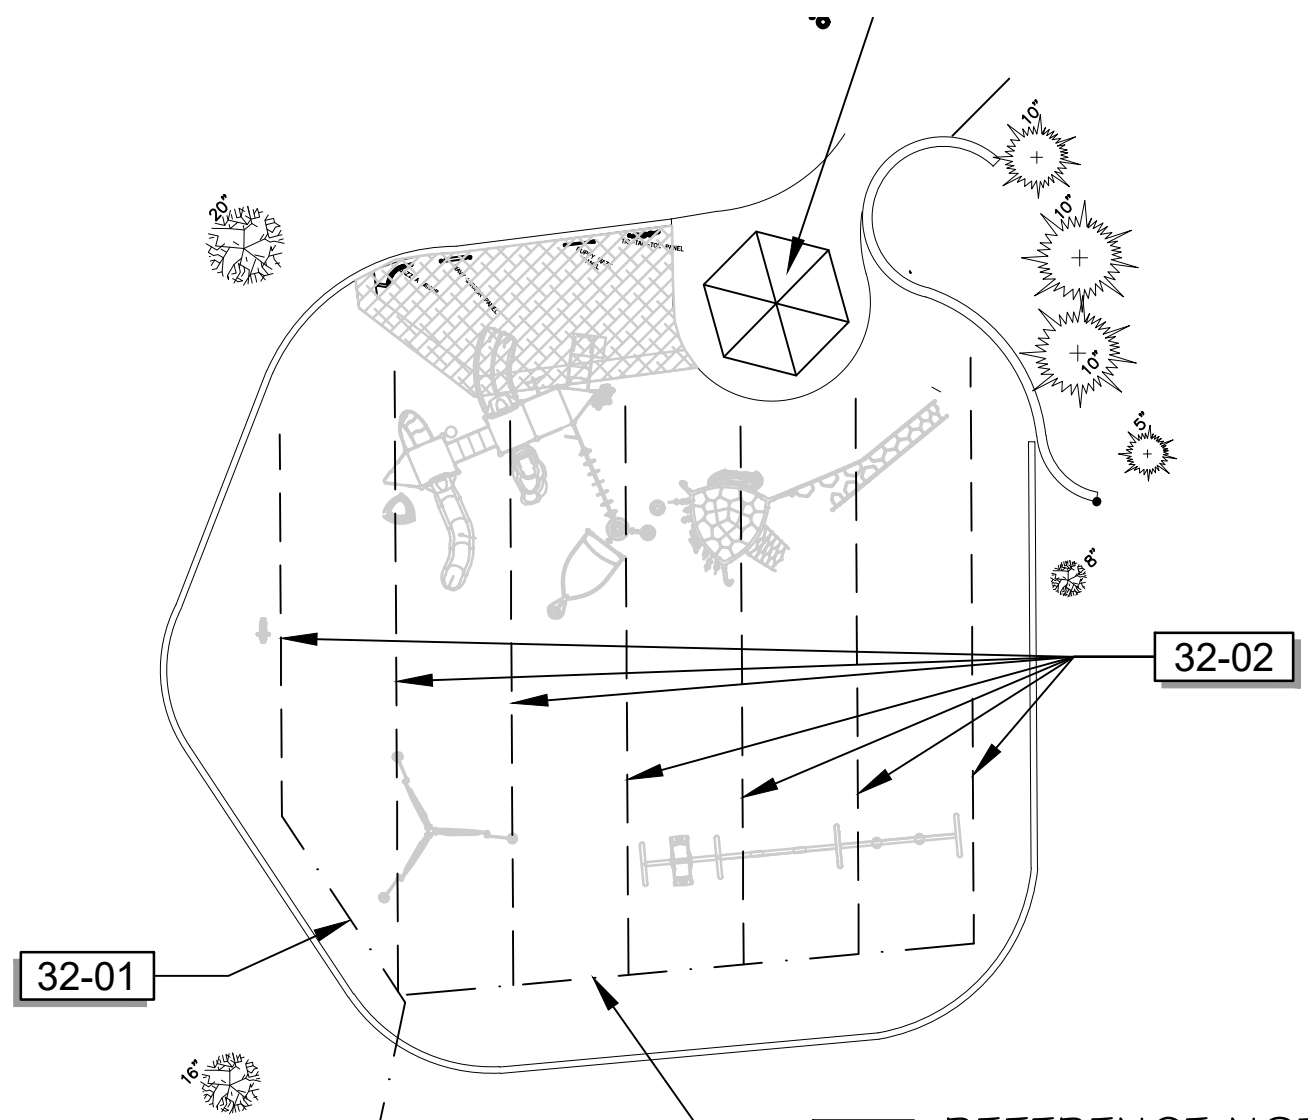

REFERENCE NOTES SCHEDULE WILLOW DRAIN

SYMBOL	32 EXTERIOR IMPROVEMENTS DESCRIPTION	QTY	DETAIL
32-01	4" ROUND PERF. DRAIN TILE	109 LF	
32-02	6" PERF. FLAT PIPE	397 LF	


WILLOW PARK PLAYGROUND DRAINAGE PLAN
SCALE 1" = 20 FT

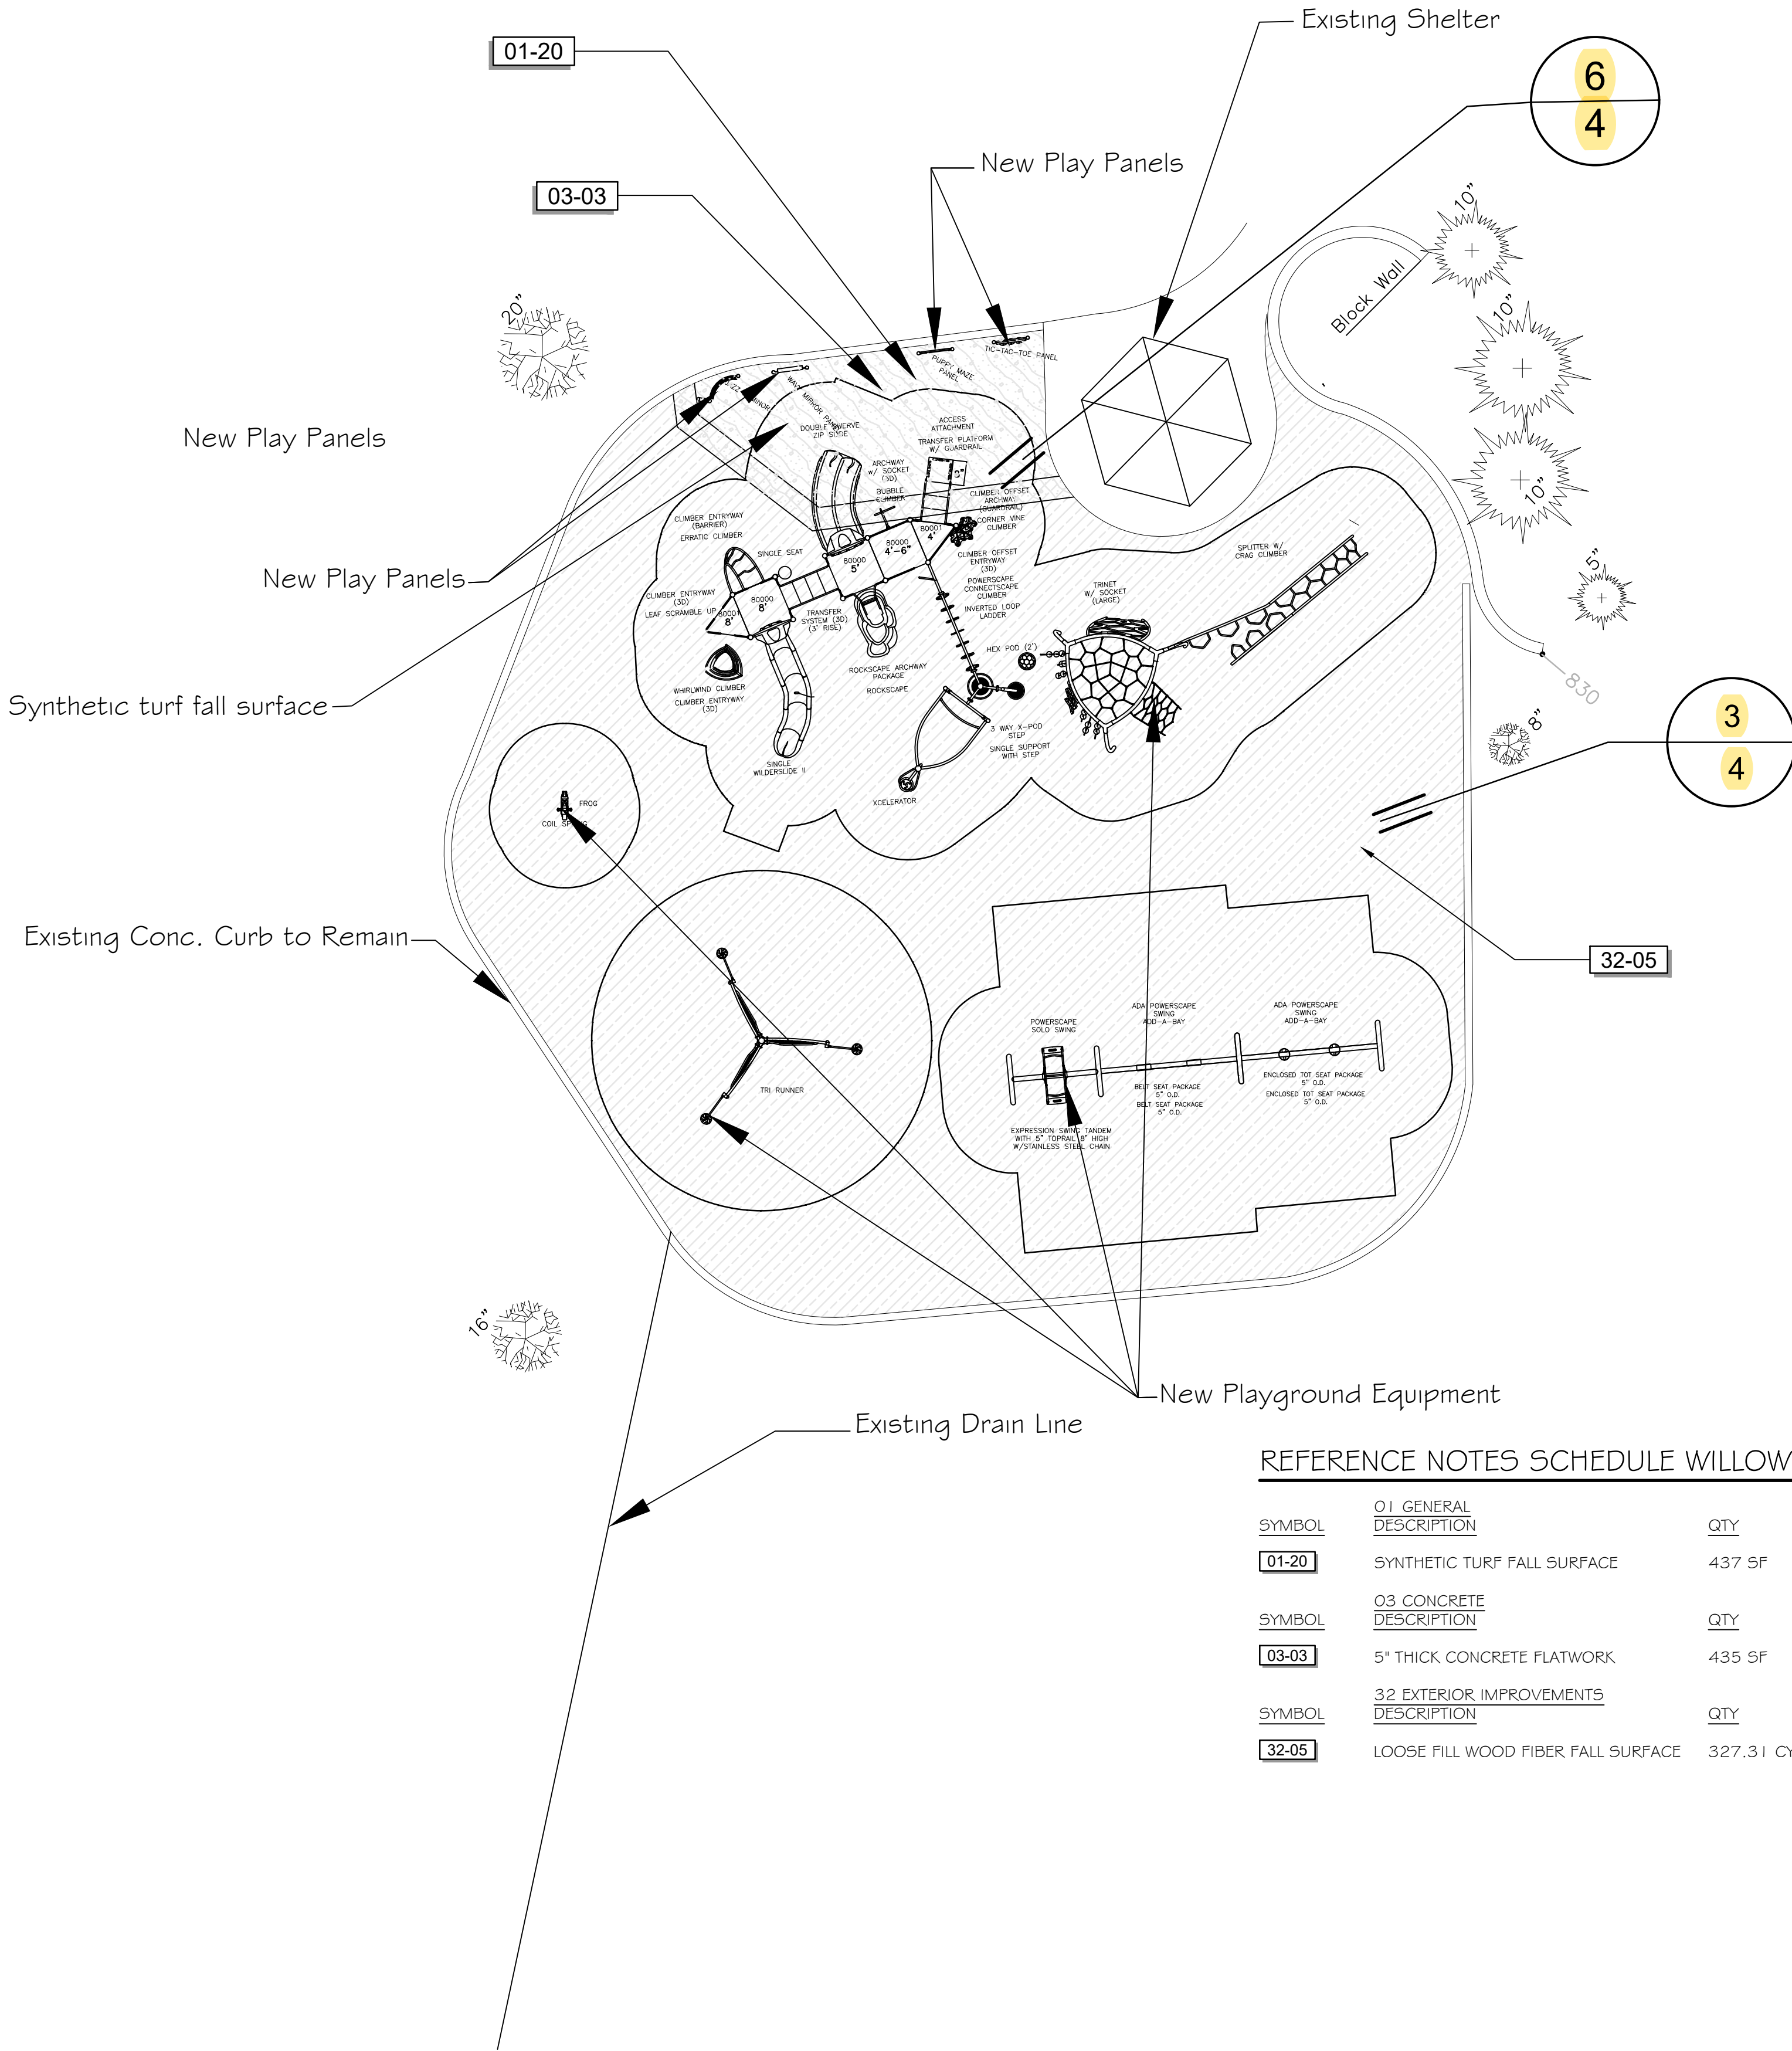


REFERENCE NOTES SCHEDULE WILLOW NEW PG


SYMBOL	01 GENERAL DESCRIPTION	QTY	DETAIL
01-20	SYNTHETIC TURF FALL SURFACE	437 SF	
SYMBOL	03 CONCRETE DESCRIPTION	QTY	DETAIL
03-03	5" THICK CONCRETE FLATWORK	435 SF	
SYMBOL	32 EXTERIOR IMPROVEMENTS DESCRIPTION	QTY	DETAIL
32-05	LOOSE FILL WOOD FIBER FALL SURFACE	327.31 CY	

WILLOW PARK NEW PLAYGROUND OVERALL PLAN
SCALE 1" = 10 FT

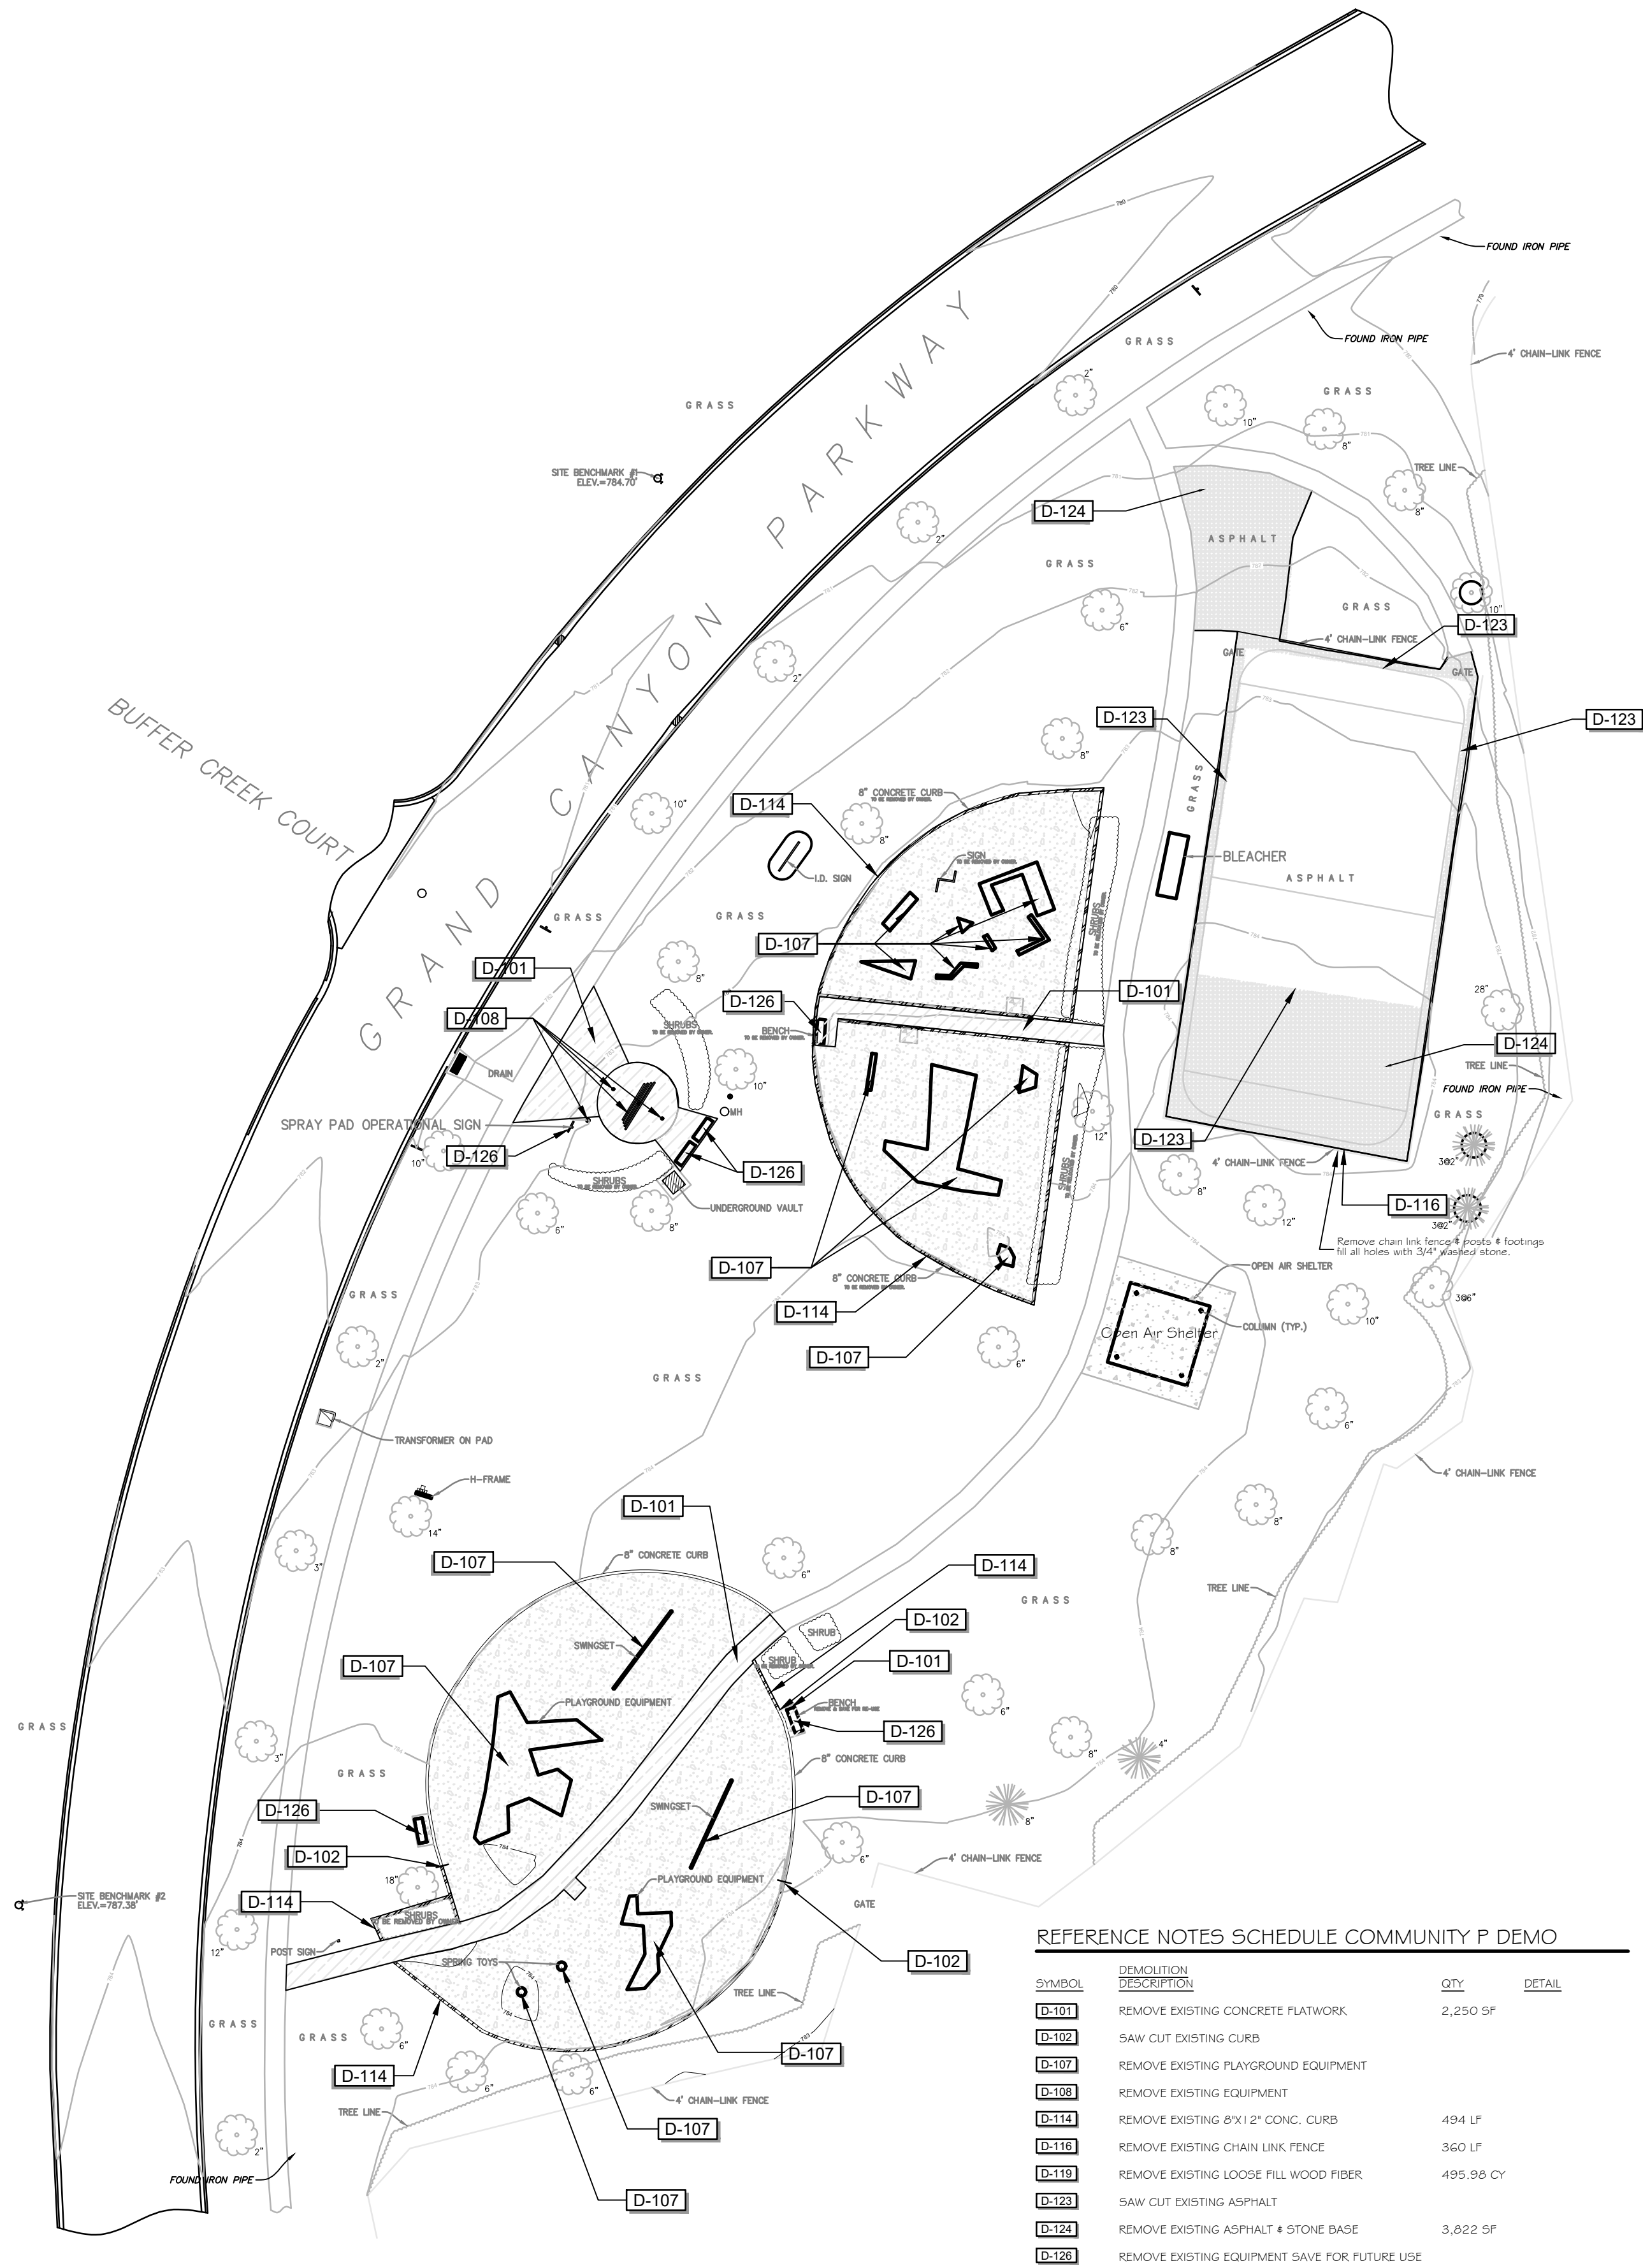


COMMUNITY PARK DEMOLITION PLAN
SCALE 1" = 30 FT

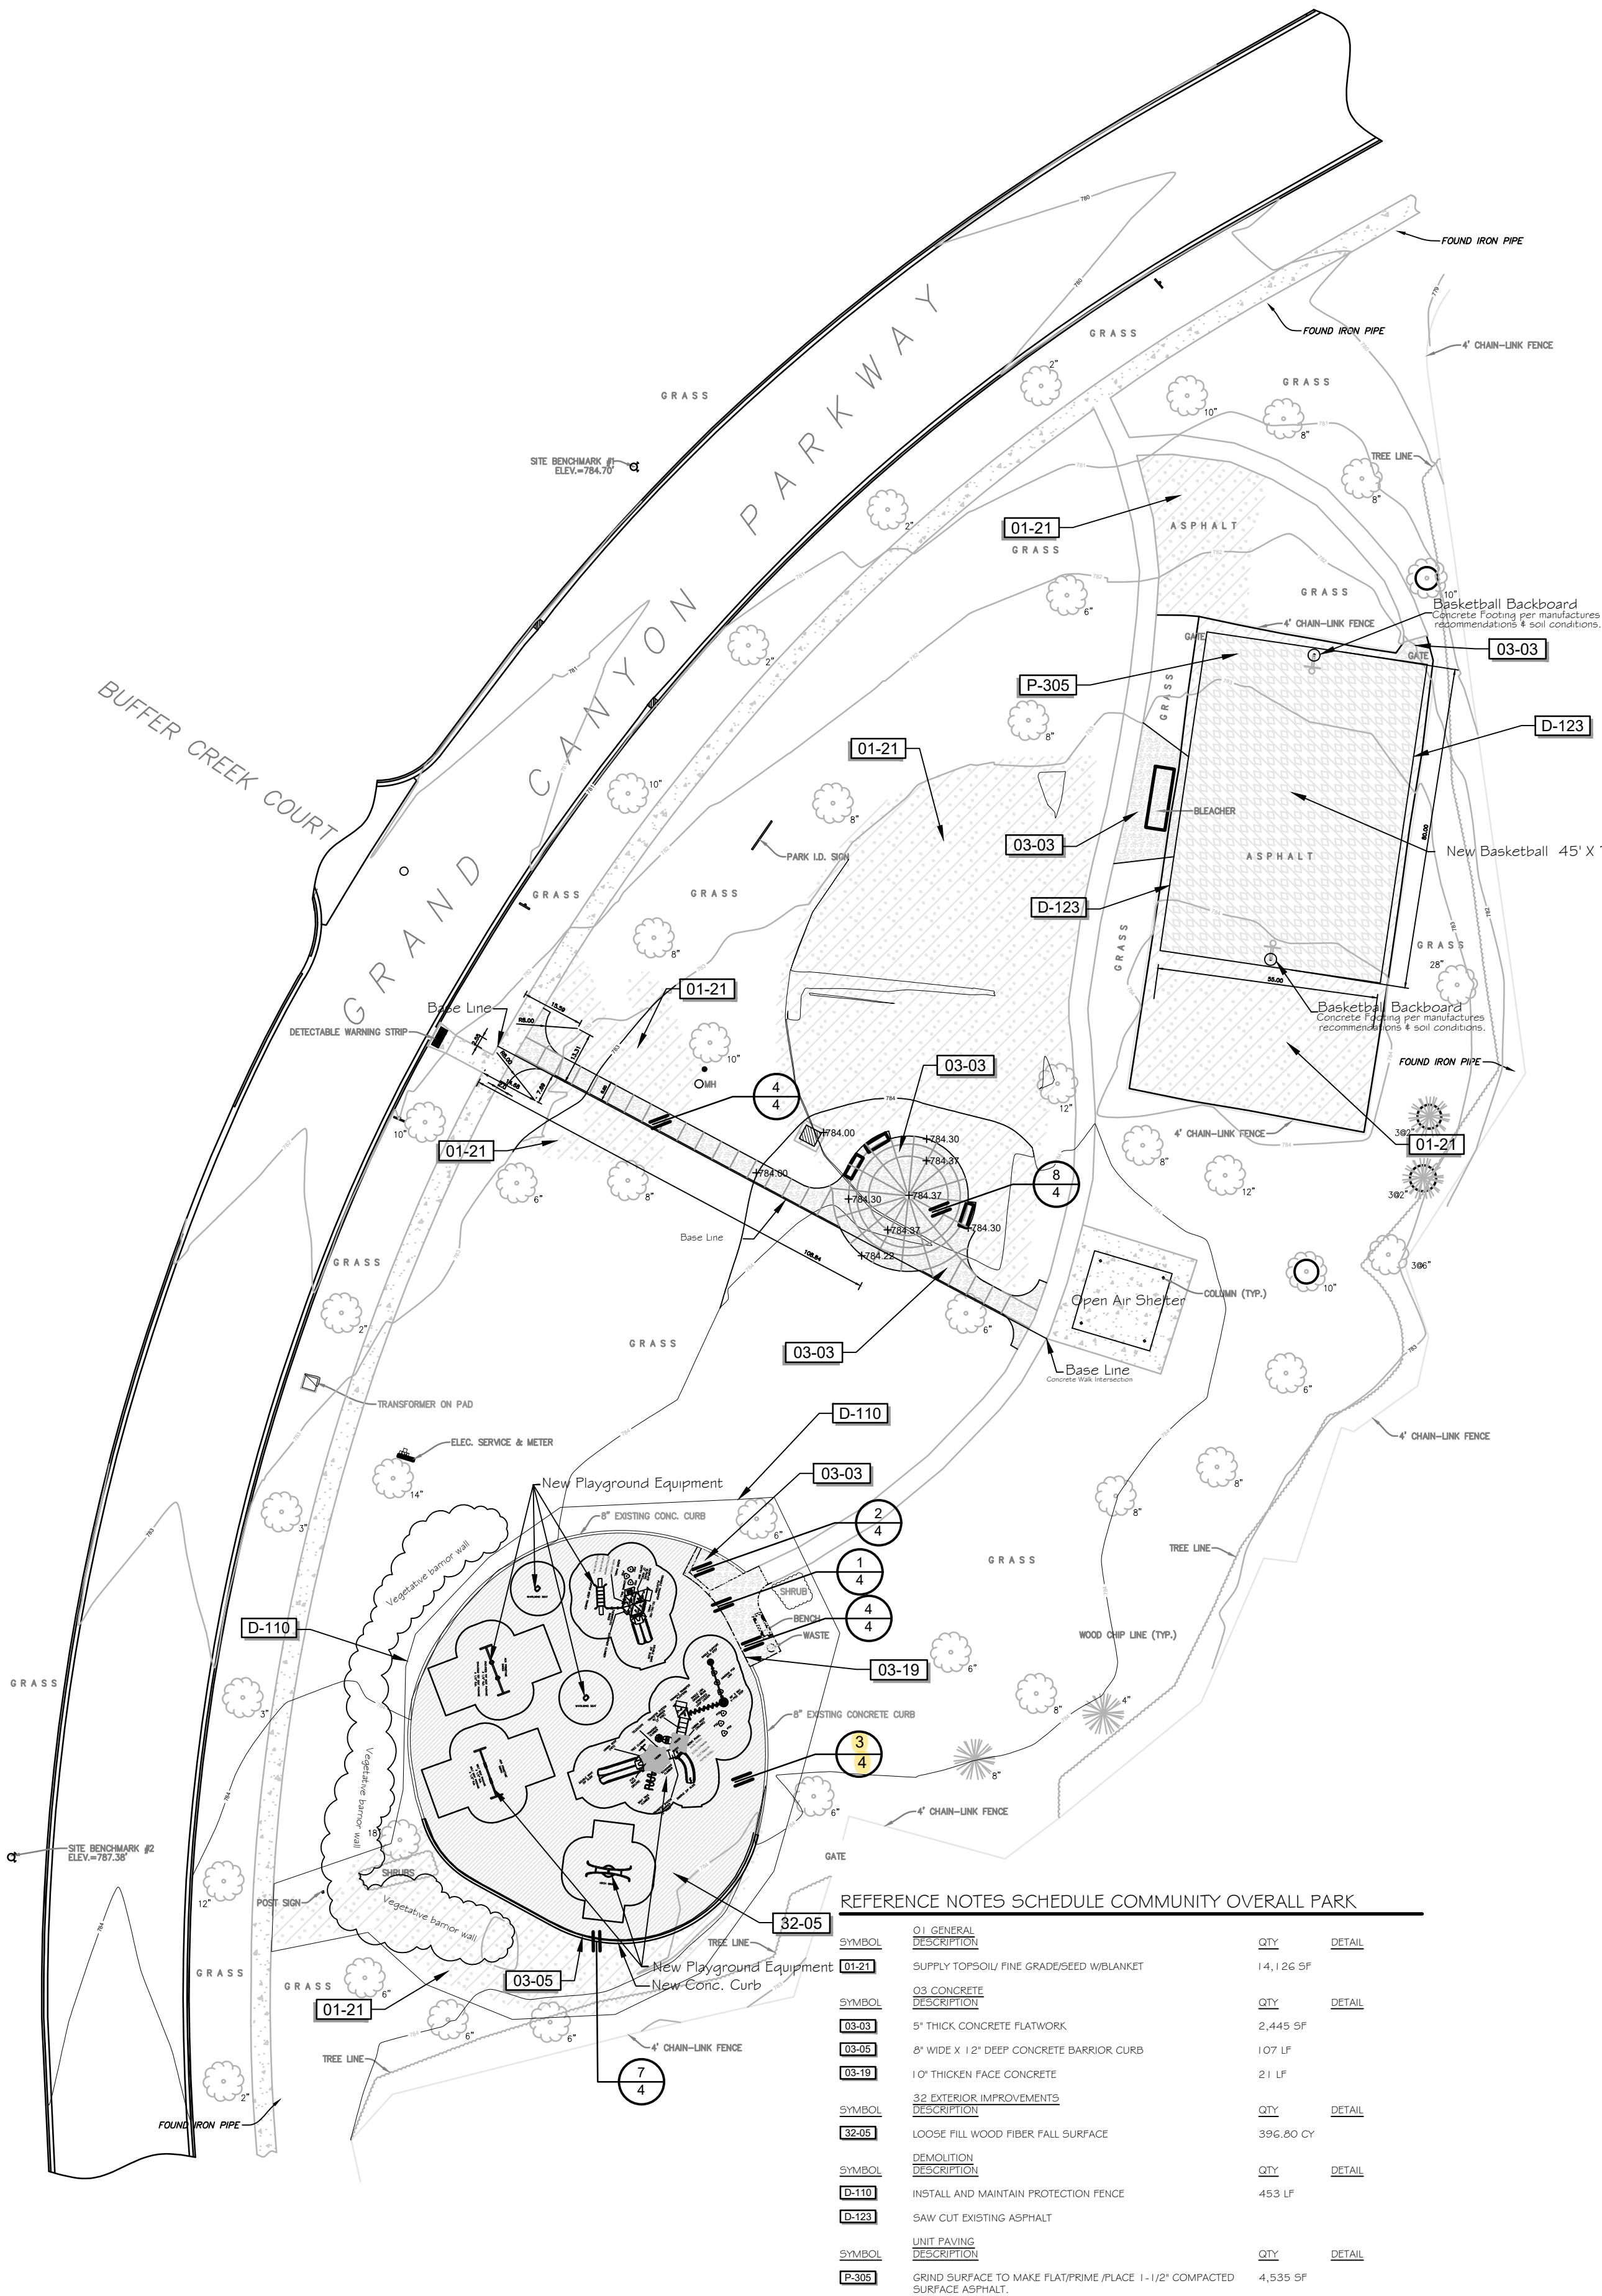

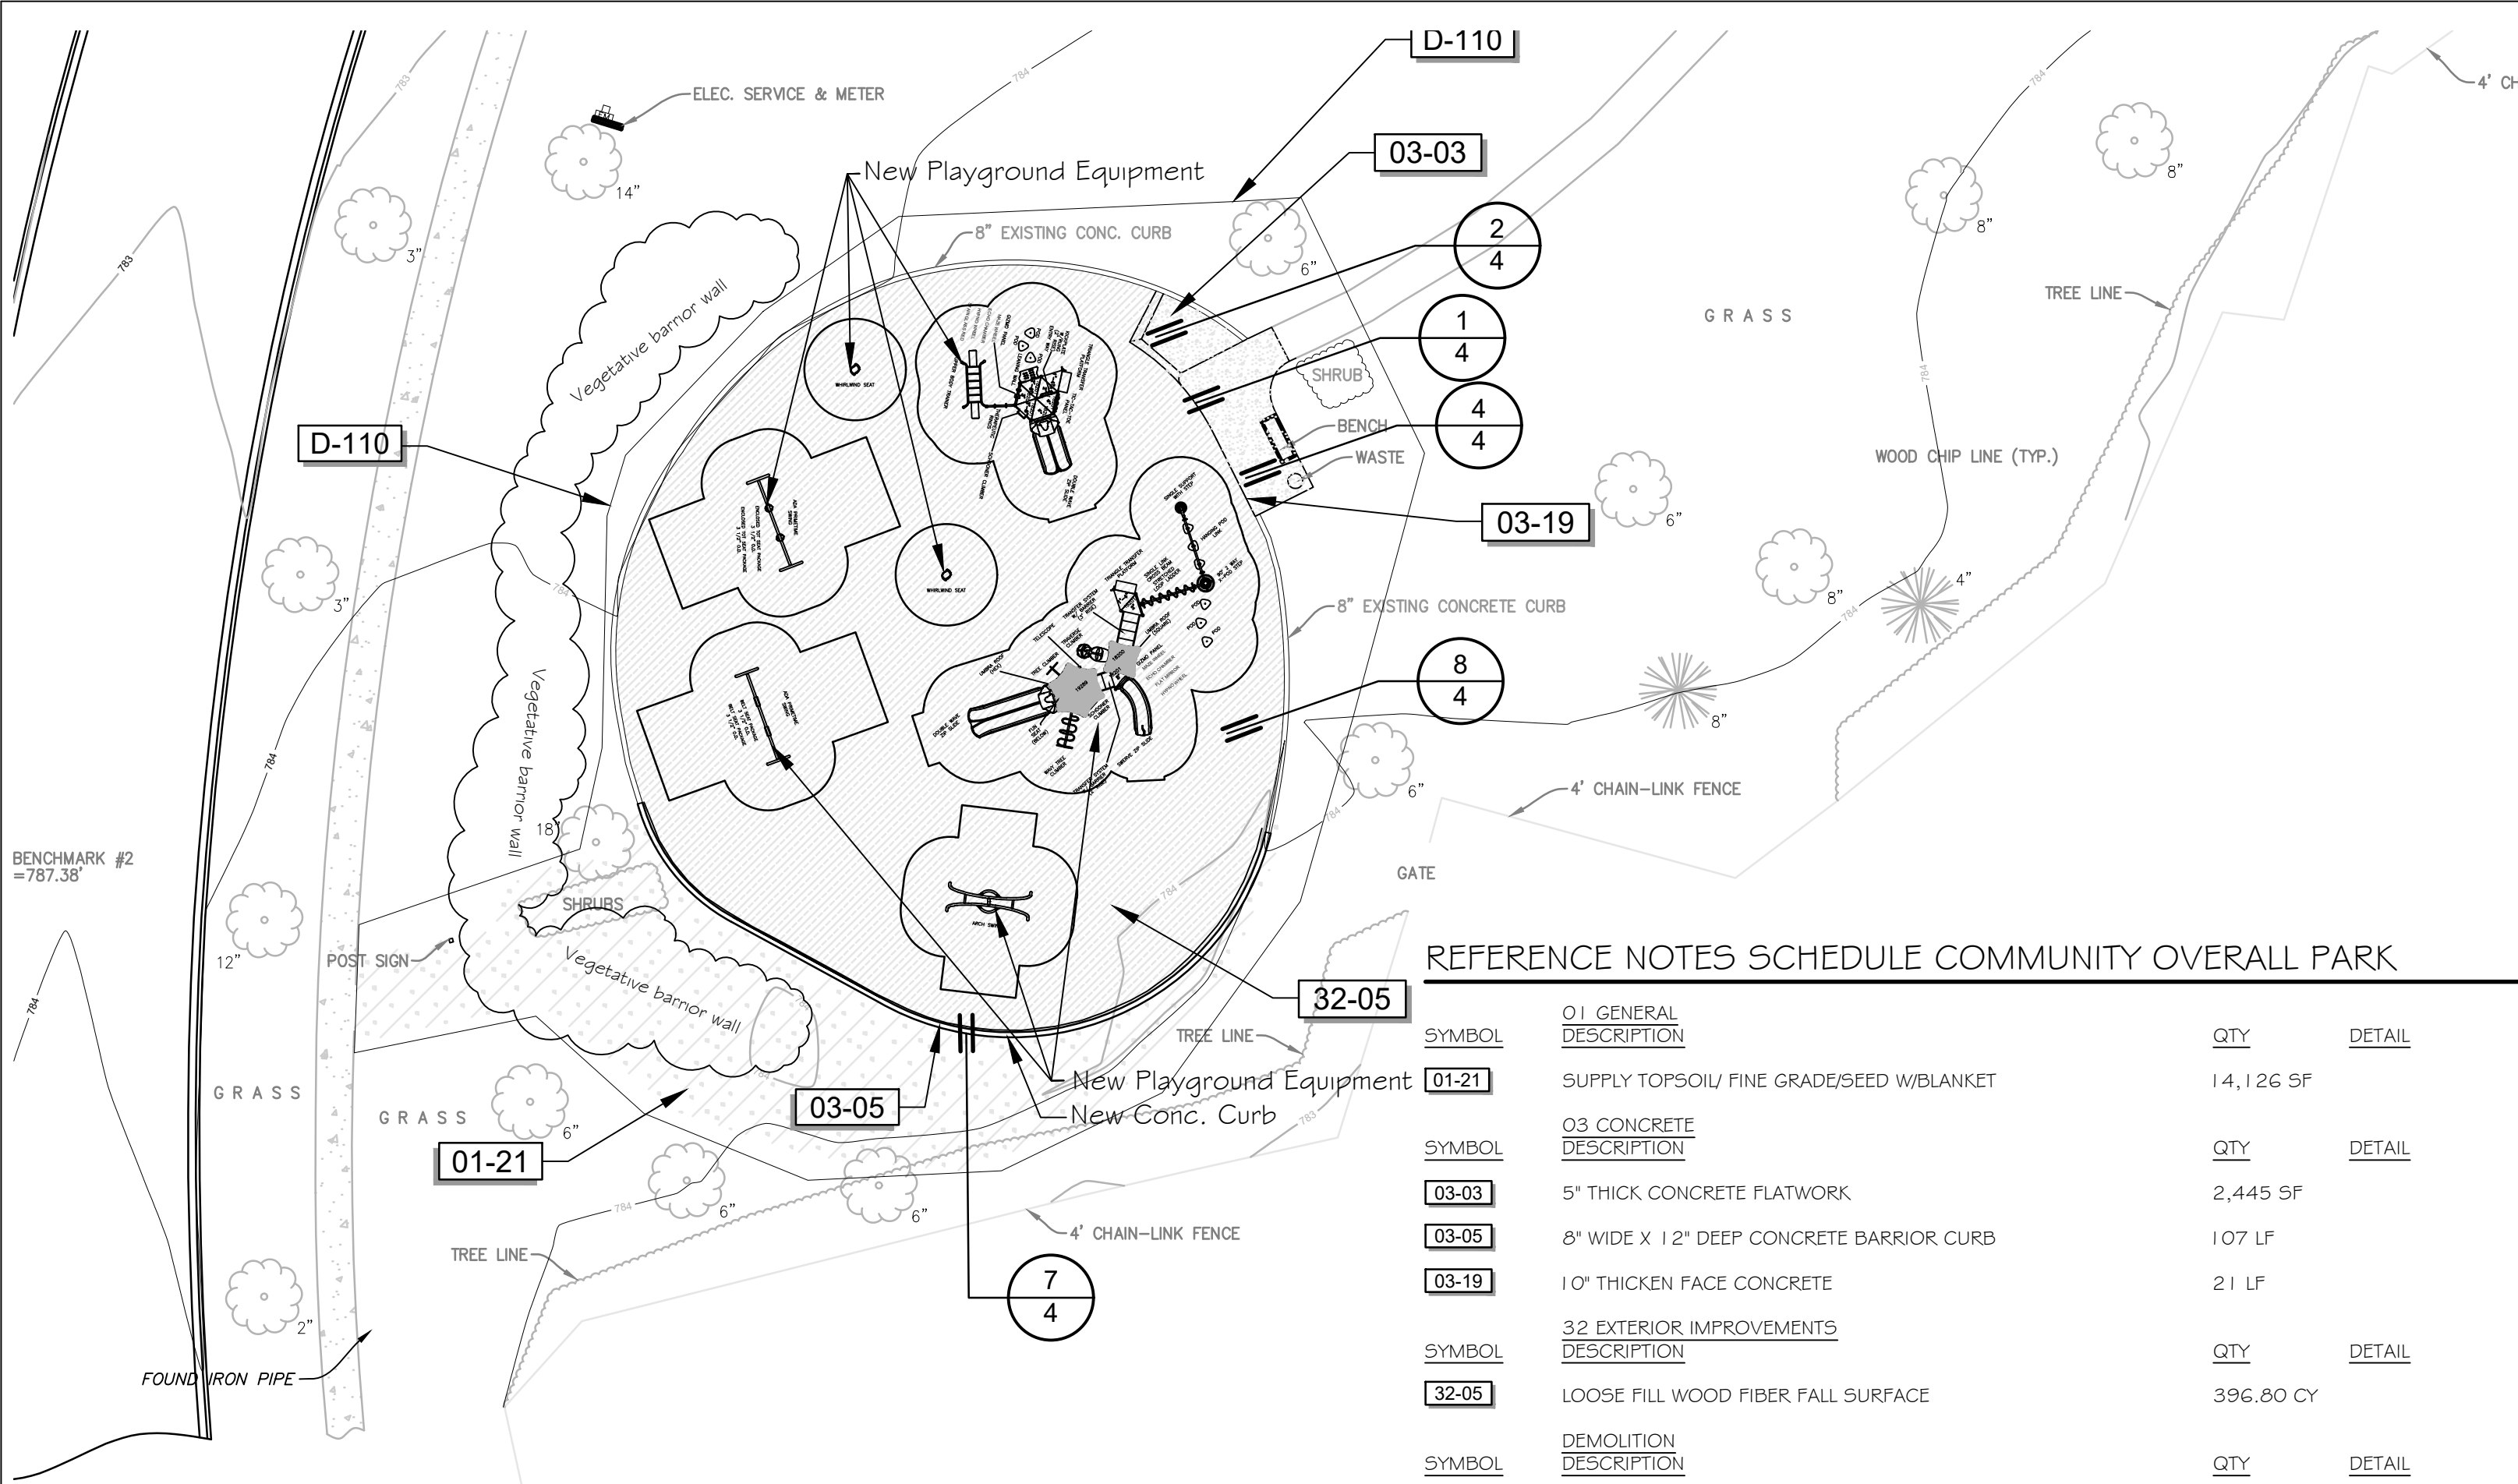


COMMUNITY PARK ENLARGED PLAYGROUND PLAN
SCALE 1" = 20 FT

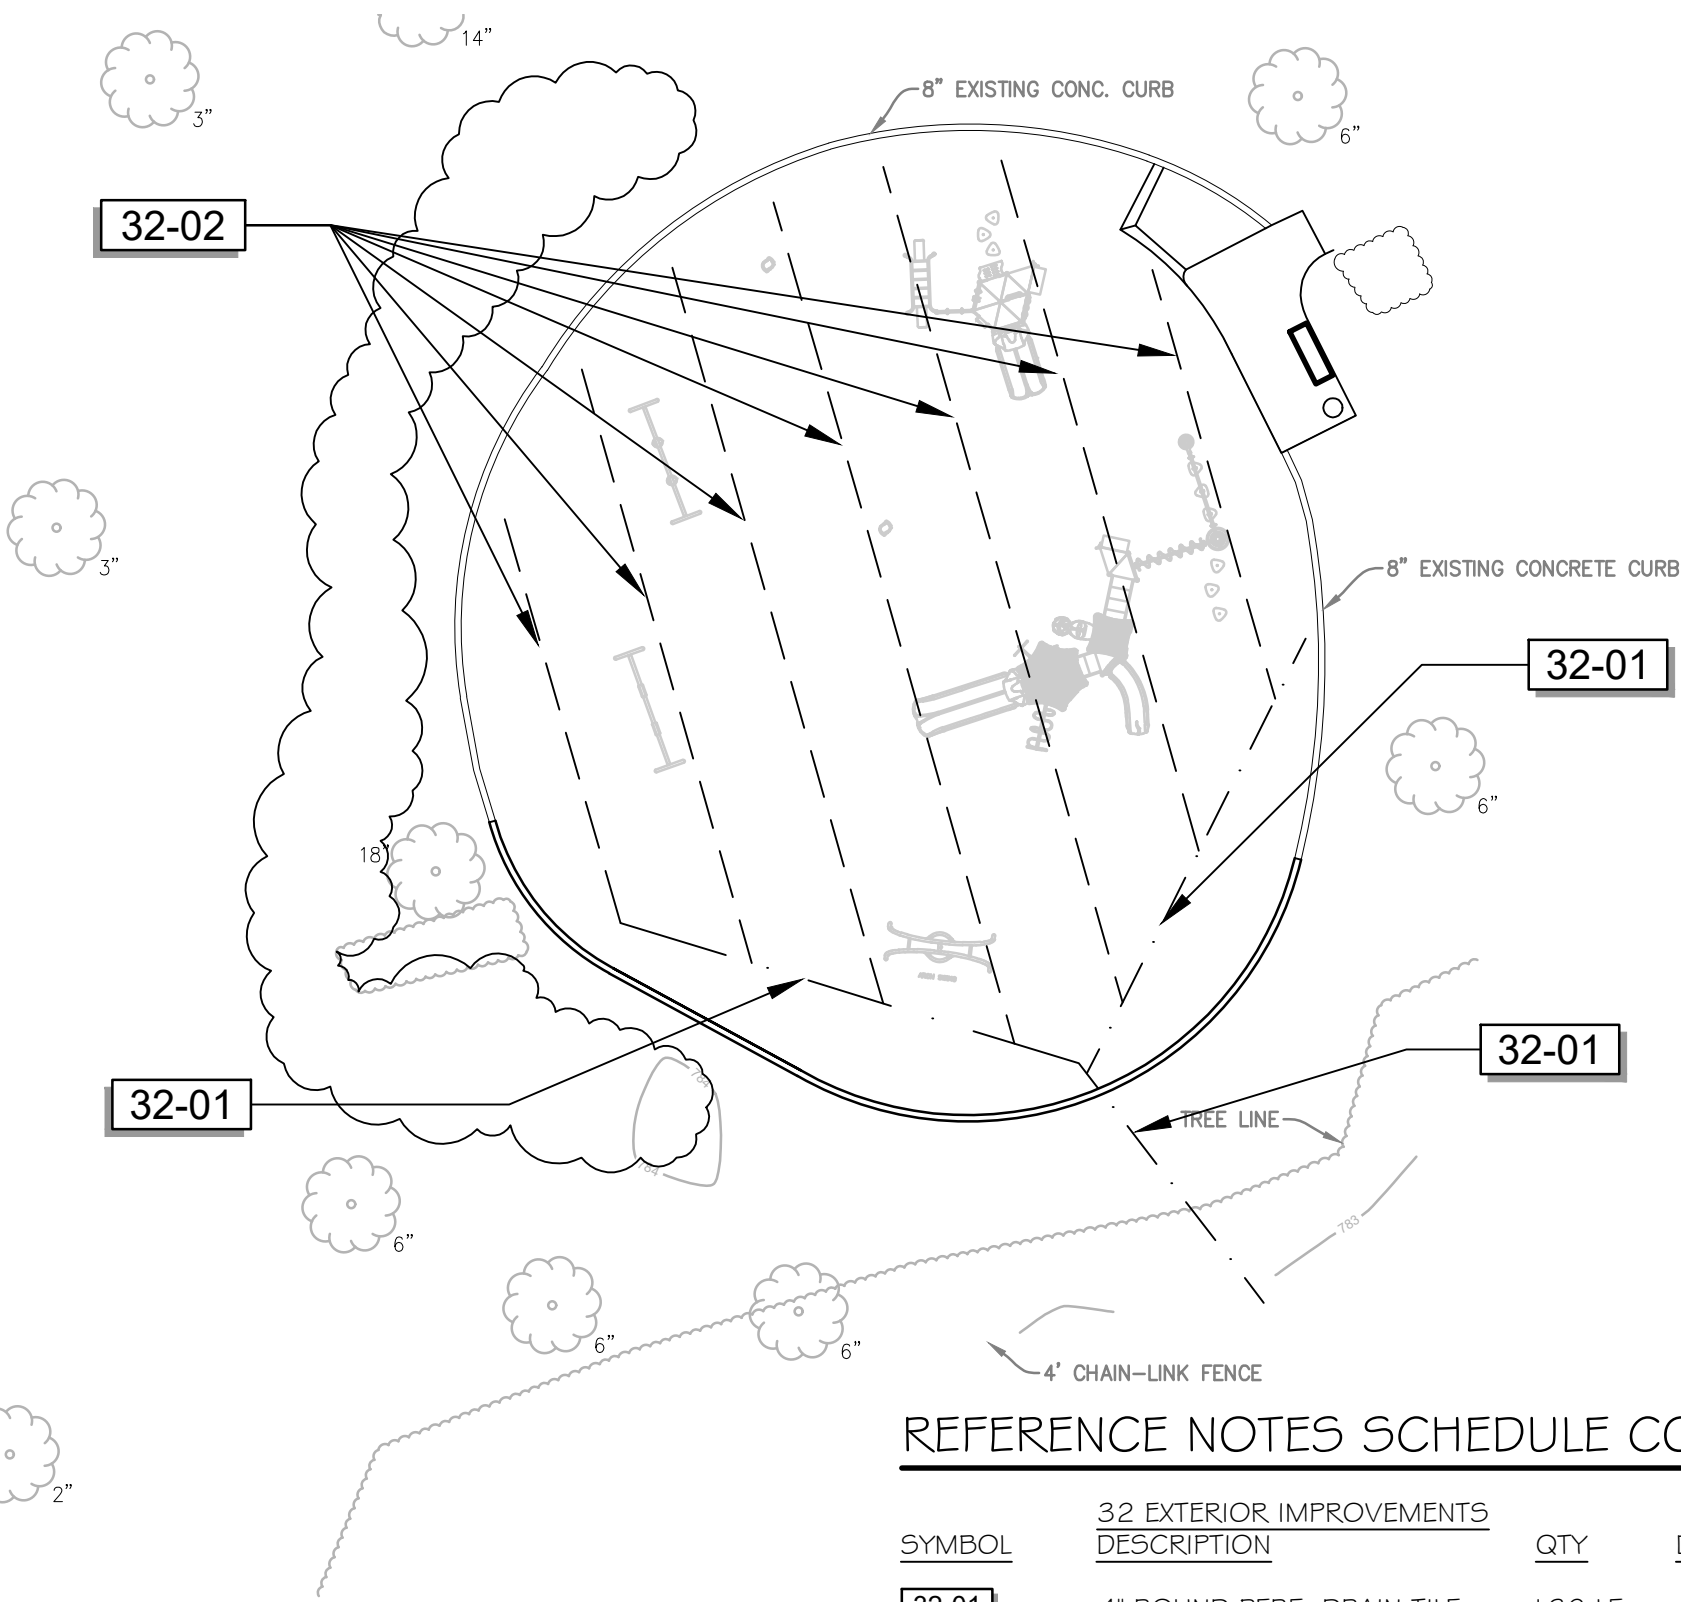


COMMUNITY PARK PLAYGROUND DRAINAGE PLAN
SCALE 1" = 20 FT


REFERENCE NOTES SCHEDULE COMMUNITY OVERALL PARK			
SYMBOL	Q1 GENERAL DESCRIPTION	QTY	DETAIL
01-21	SUPPLY TOPSOIL/ FINE GRADE/SEED W/BLANKET	14,126 SF	
SYMBOL	Q3 CONCRETE DESCRIPTION	QTY	DETAIL
03-03	5" THICK CONCRETE FLATWORK	2,445 SF	
03-05	8" WIDE X 12" DEEP CONCRETE BARRIER CURB	107 LF	
03-19	10" THICKEN FACE CONCRETE	21 LF	
SYMBOL	32 EXTERIOR IMPROVEMENTS DESCRIPTION	QTY	DETAIL
32-05	LOOSE FILL WOOD FIBER FALL SURFACE	396.80 CY	
SYMBOL	DEMOLITION DESCRIPTION	QTY	DETAIL
D-110	INSTALL AND MAINTAIN PROTECTION FENCE	453 LF	
D-123	SAW CUT EXISTING ASPHALT		
UNIT PAVING			

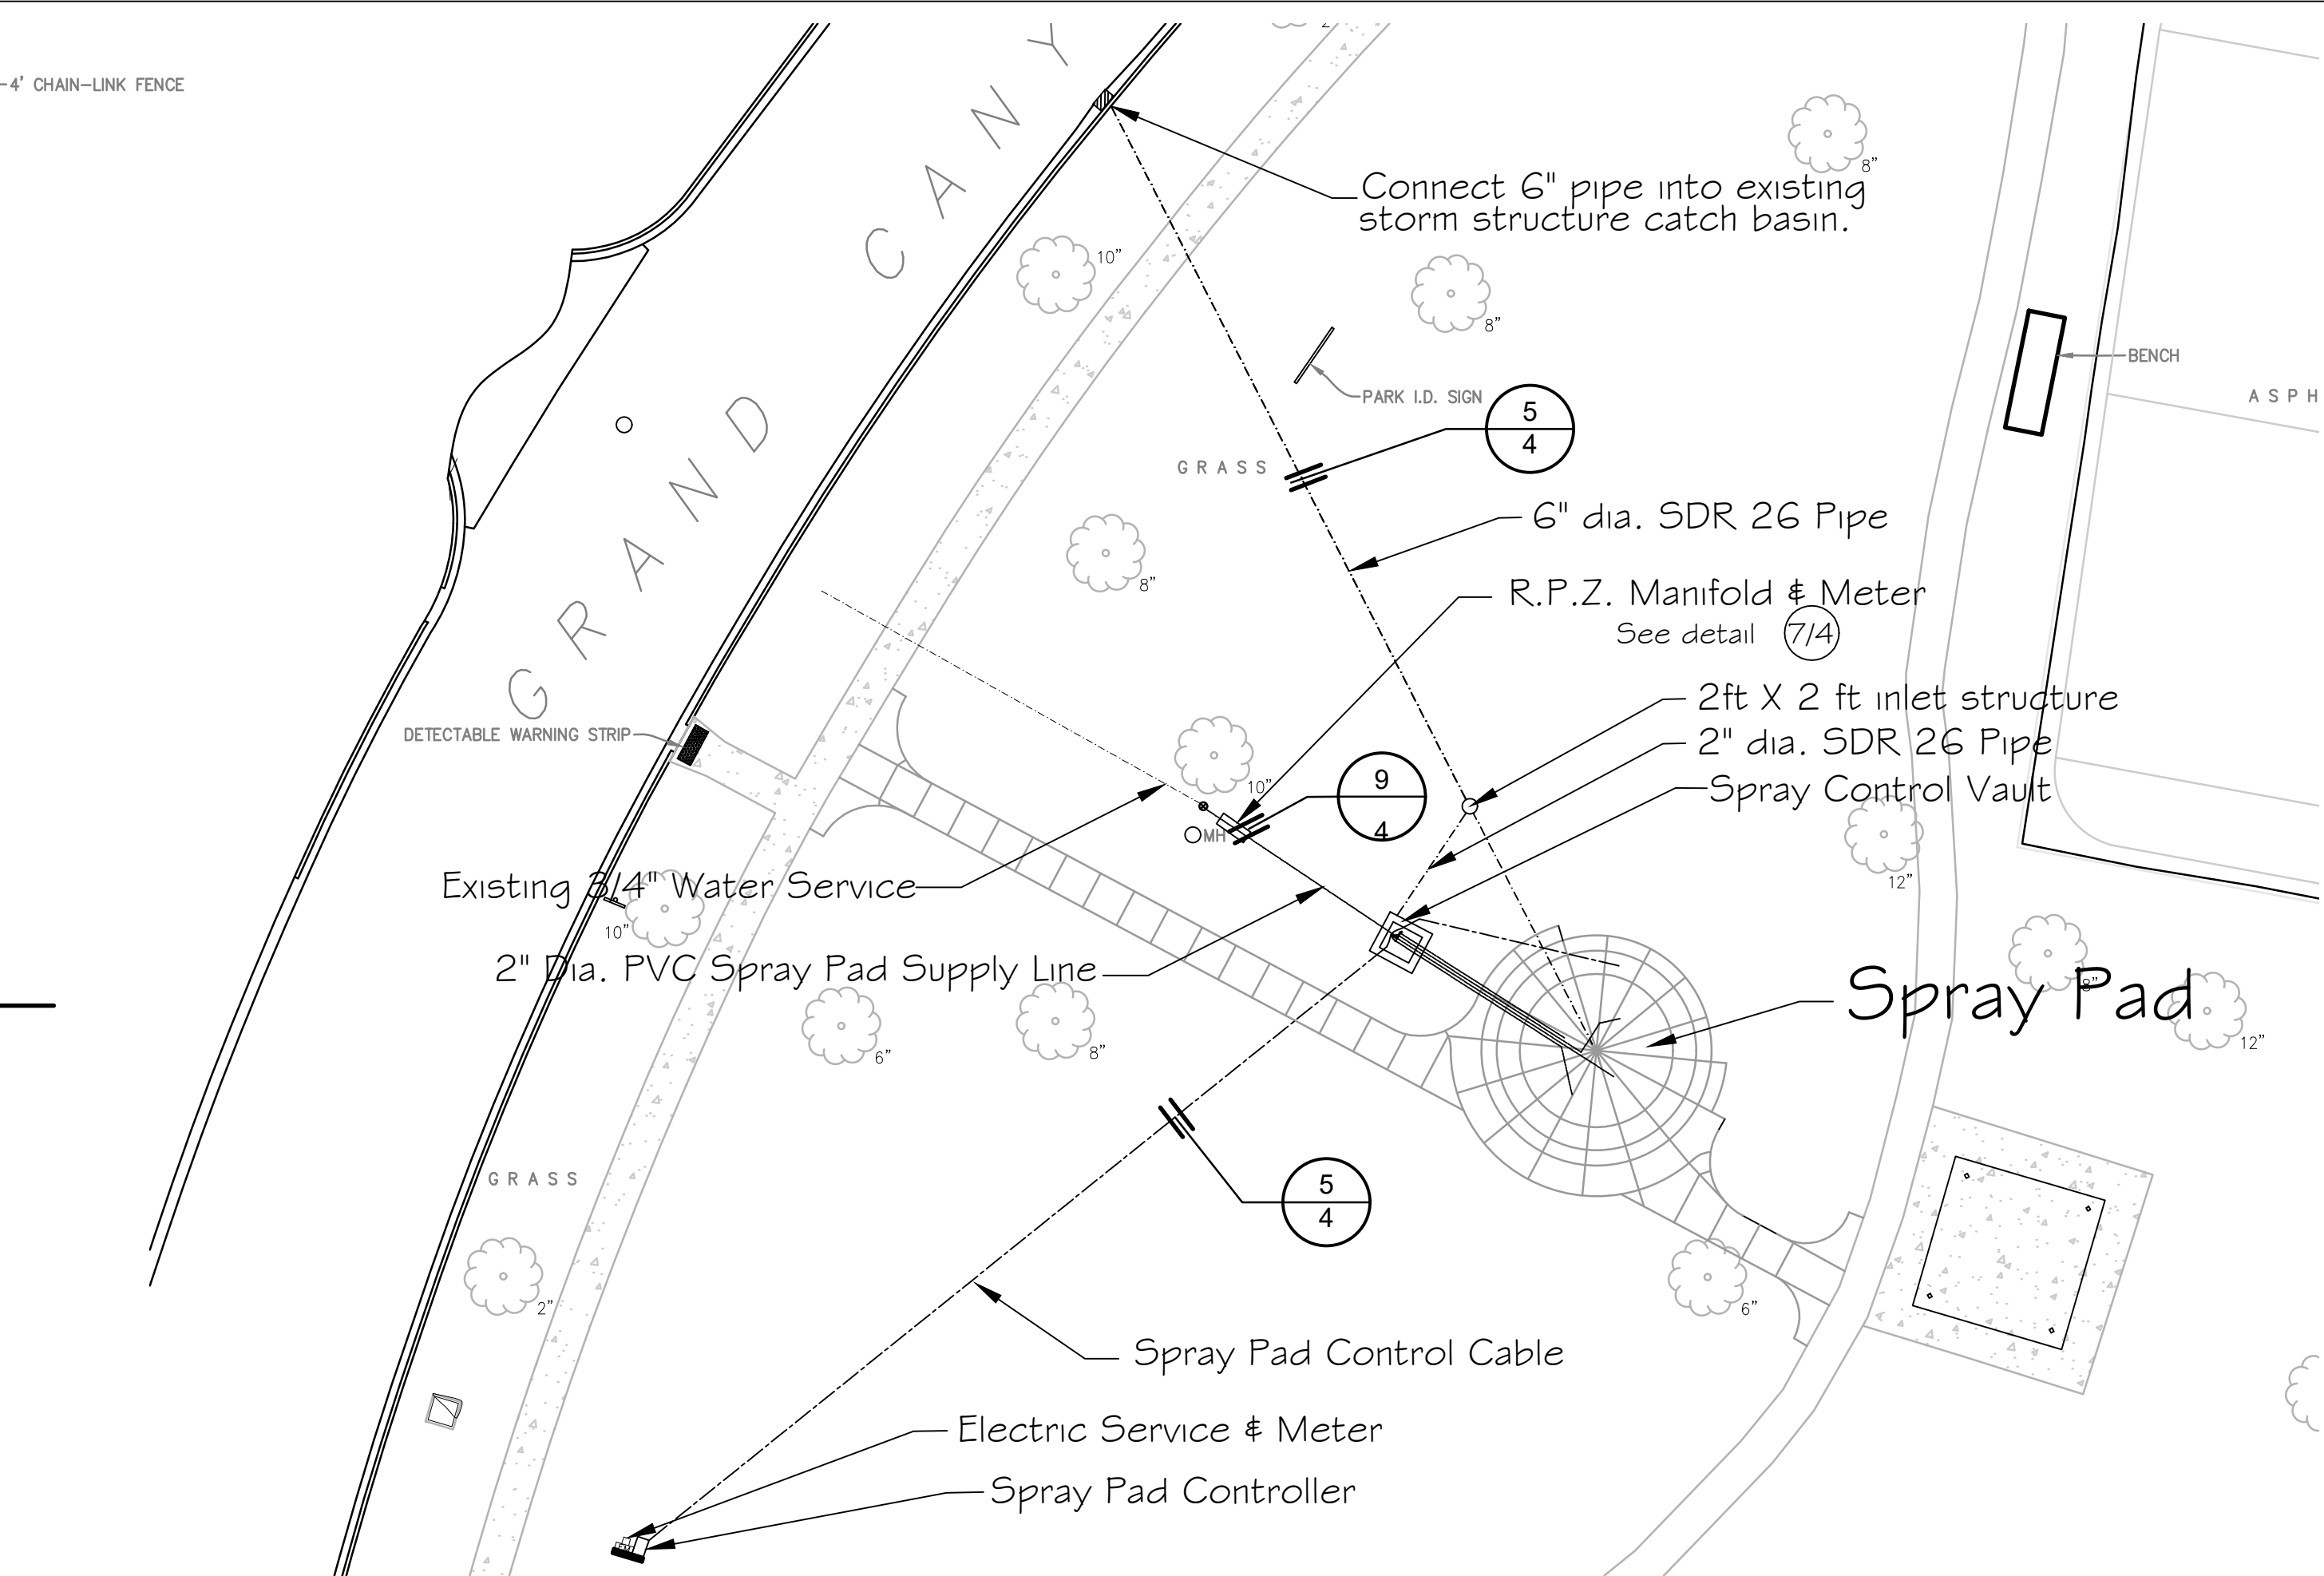


COMMUNITY PARK OVERALL SPLASH PAD PLUMBING PLAN
SCALE 1" = 20 FT

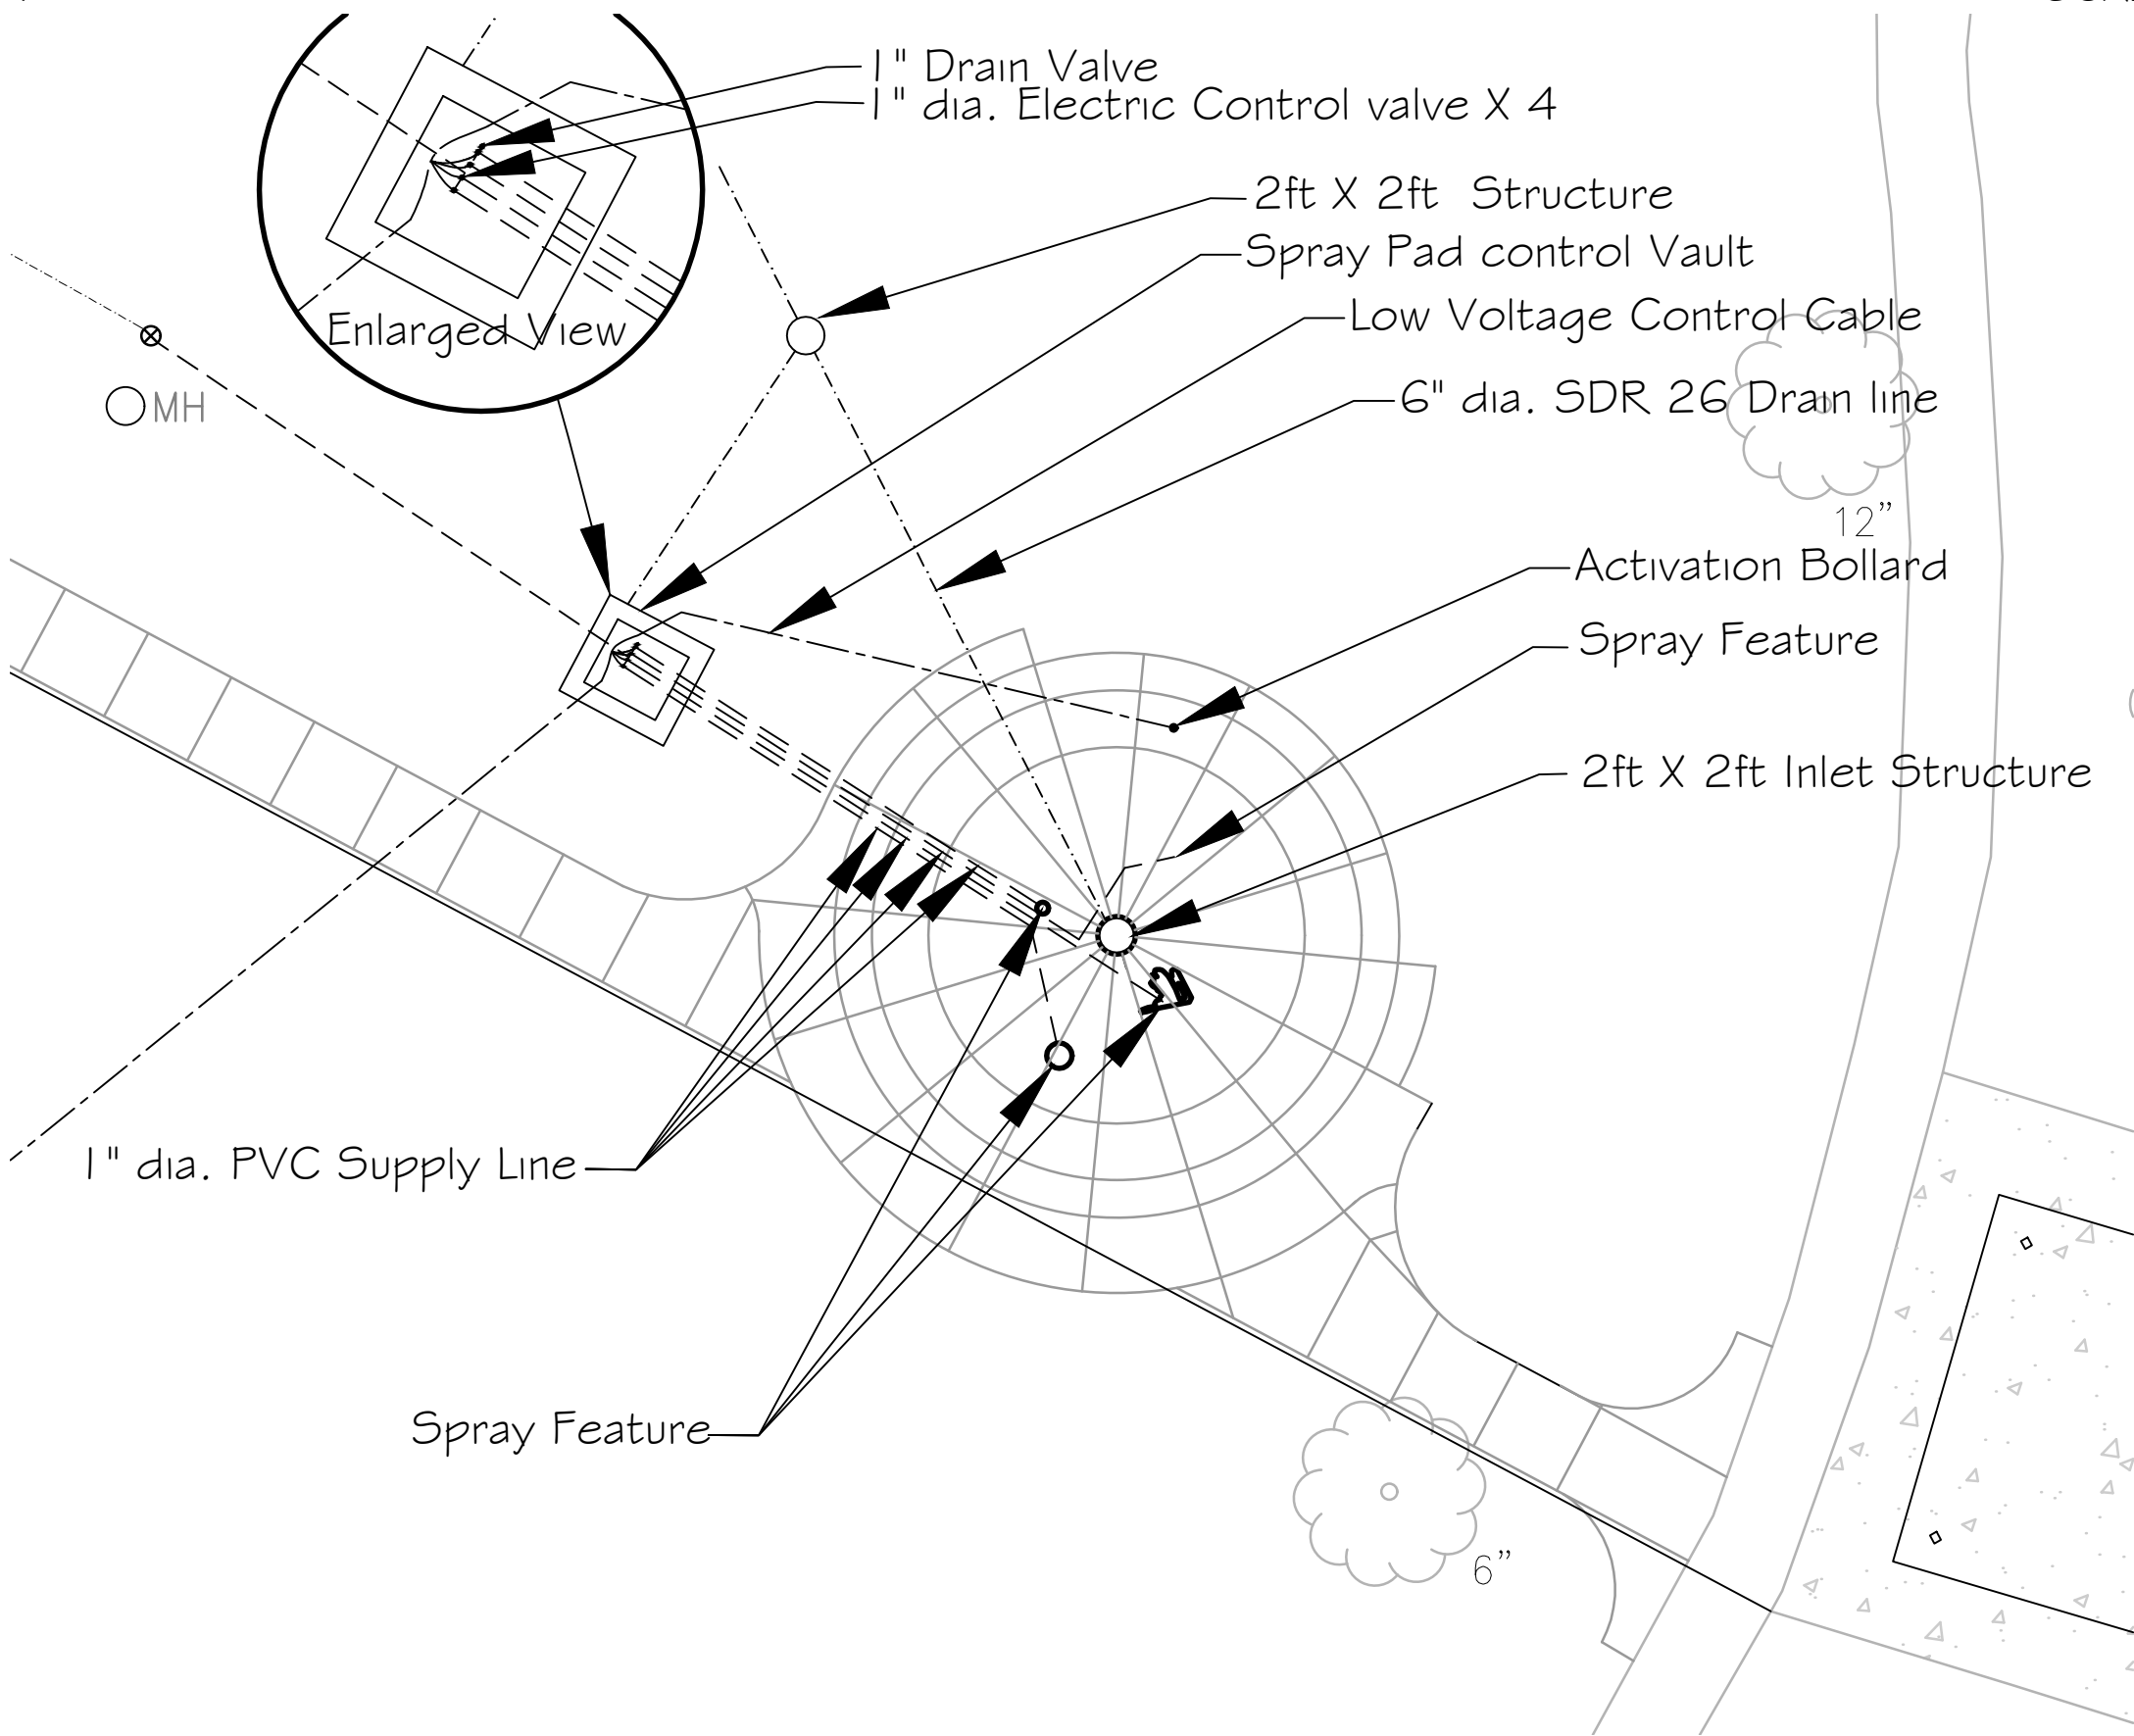

COMMUNITY PARK SPLASH PAD PLUMBING PLAN
SCALE 1" = 10 FT

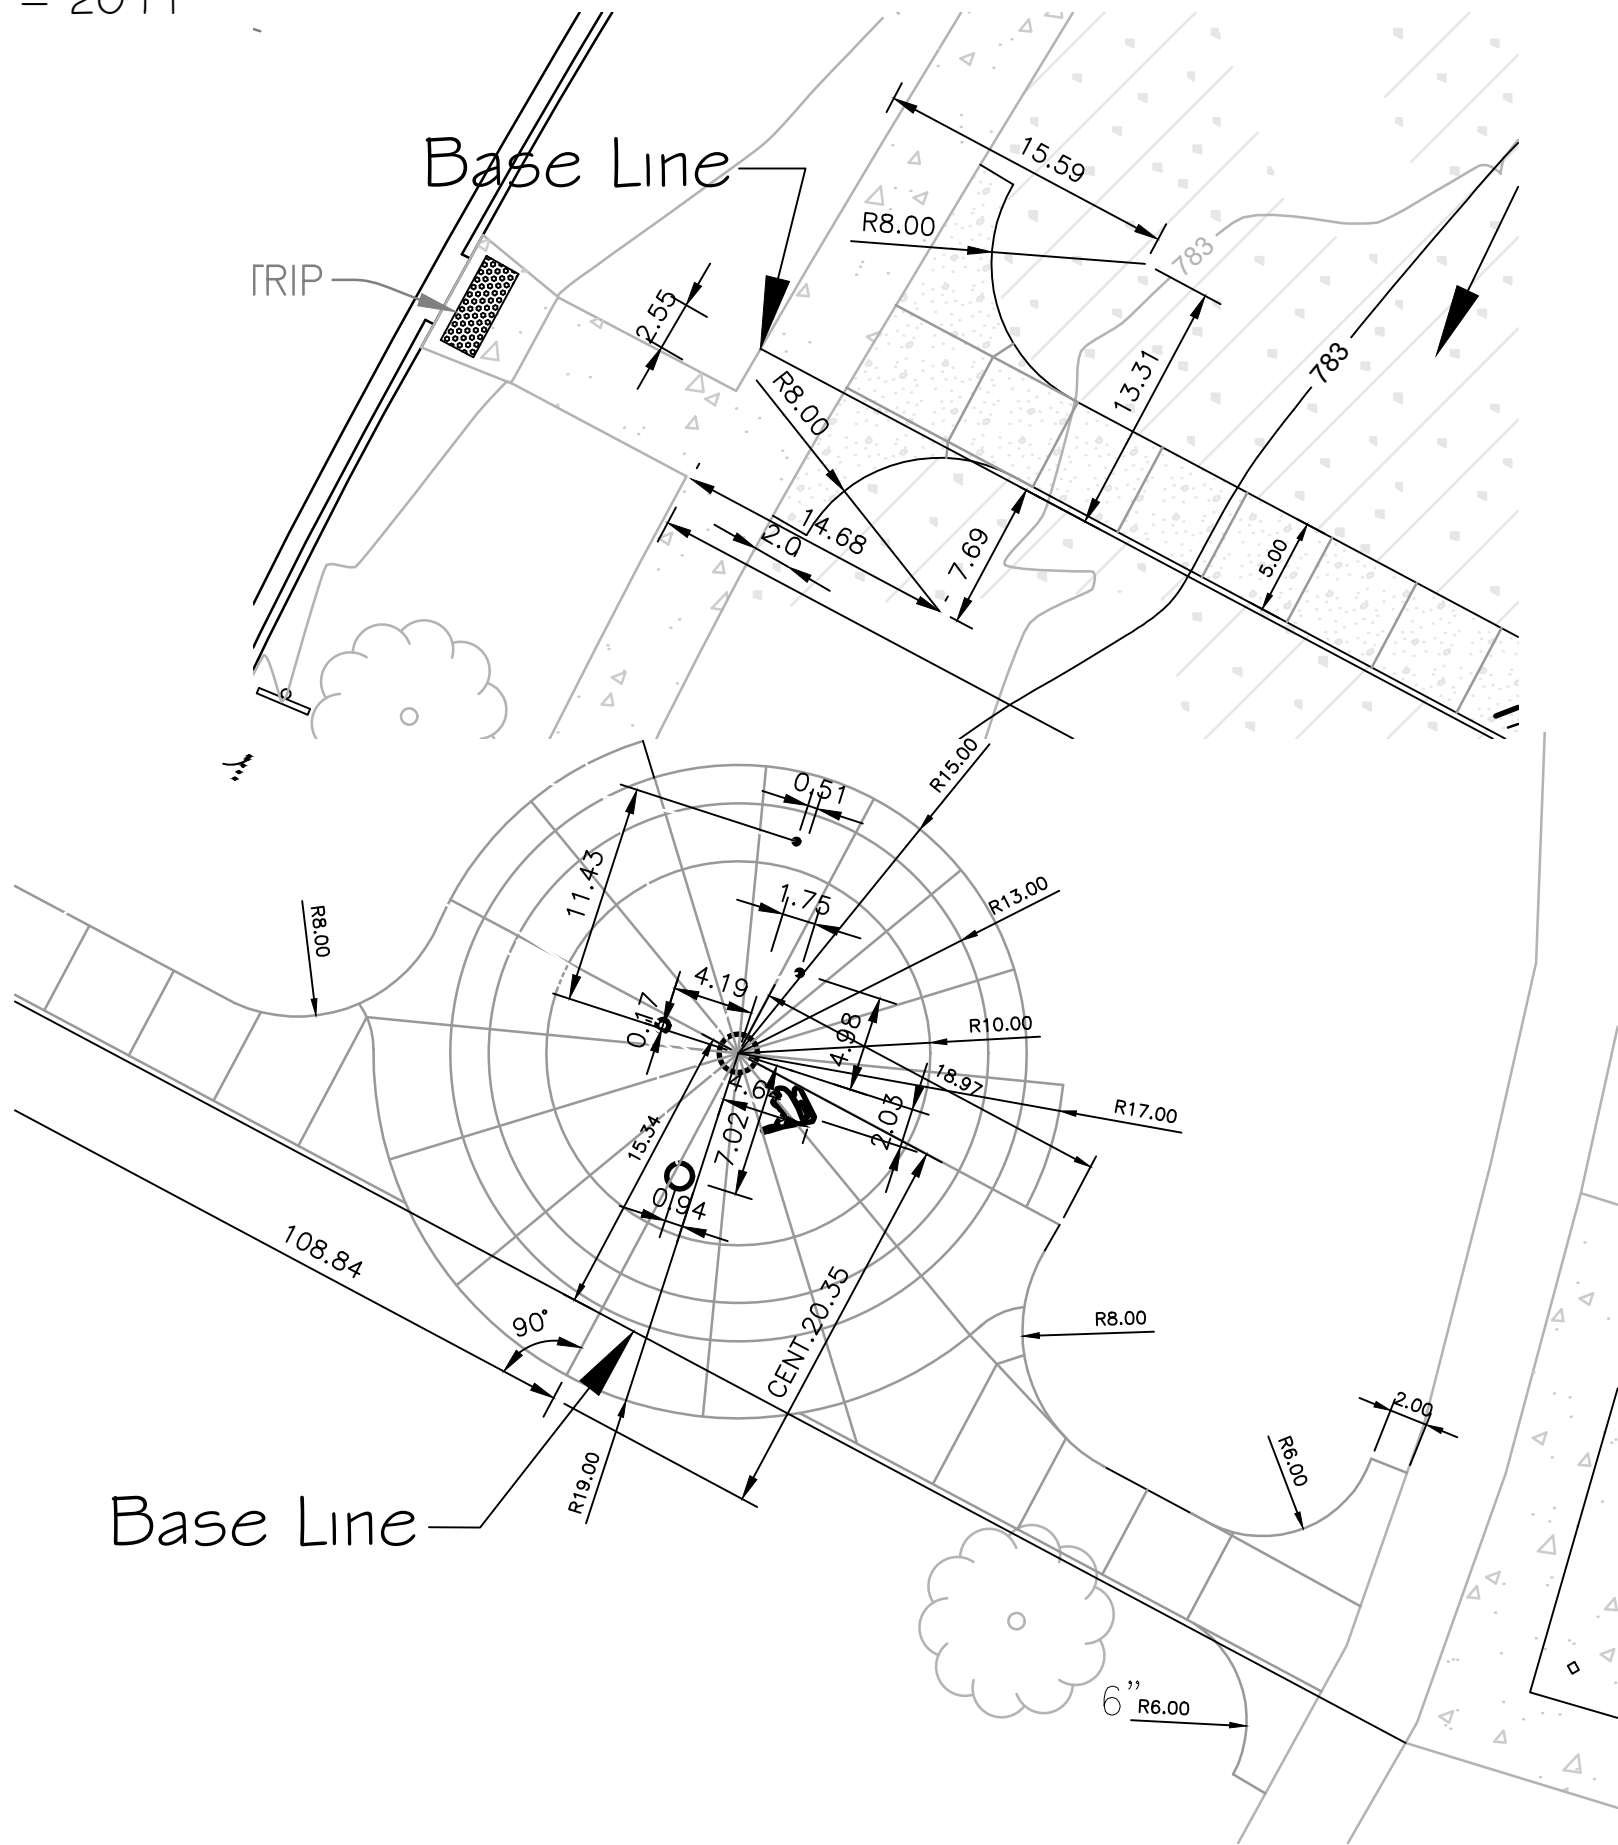


COMMUNITY PARK SPLASH PAD LAYOUT PLAN
SCALE 1" = 10 FT

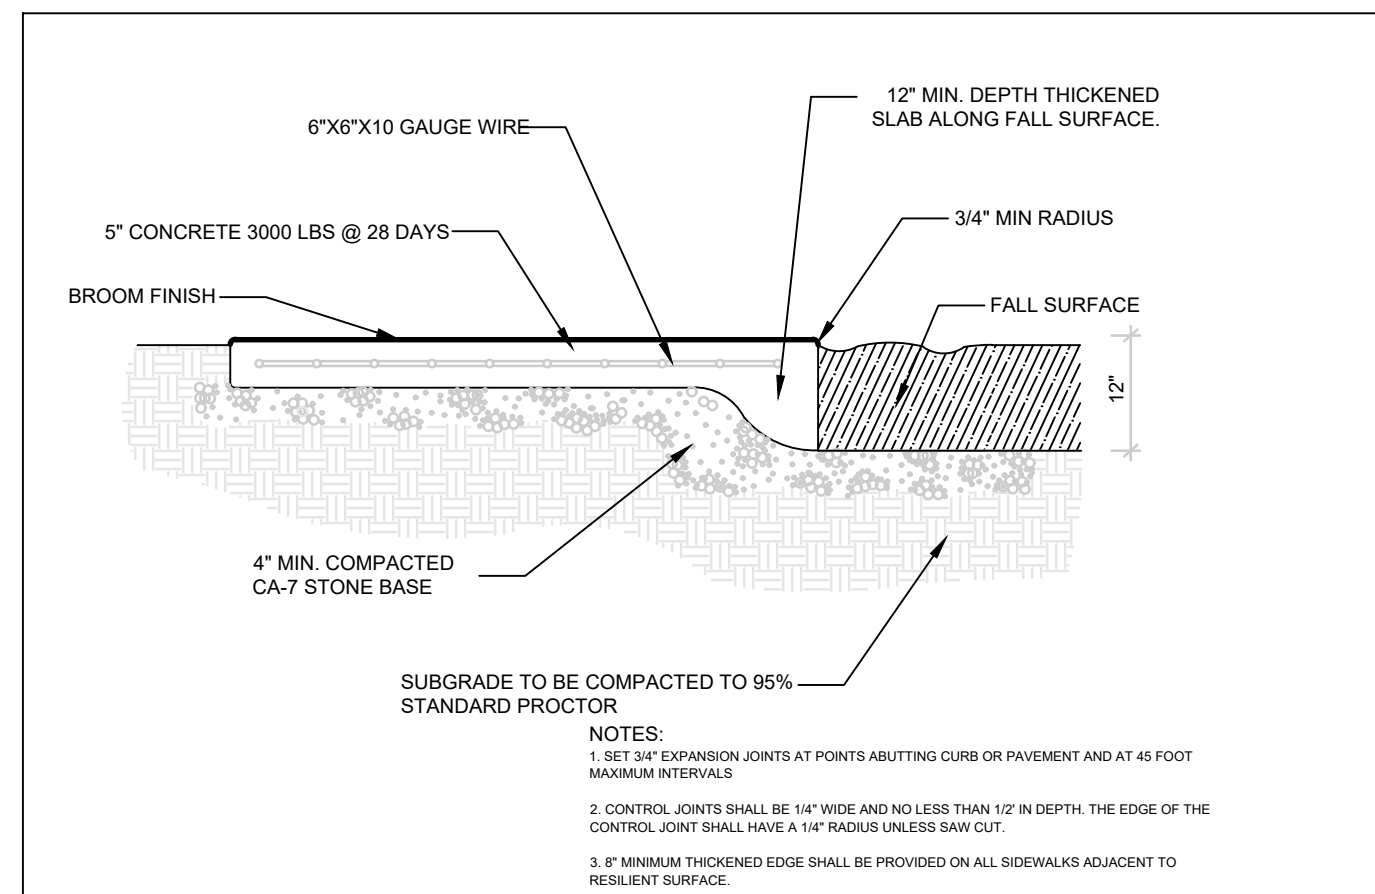

1
4

SIDEWALK DETAIL AT PLAYGROUND


No Scale

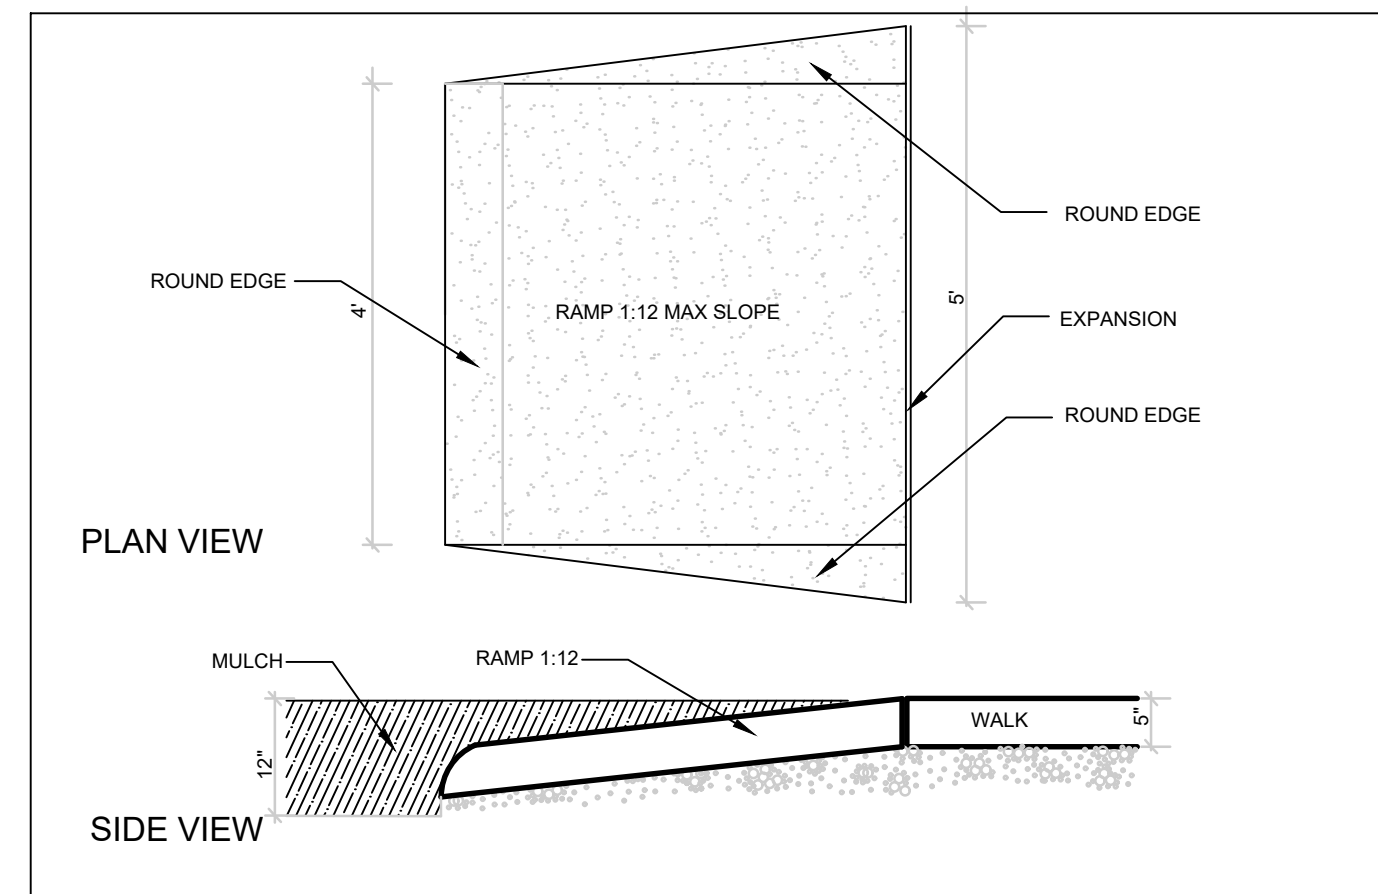

2
4

RAMP INTO PLAYGROUND DETAIL


No Scale

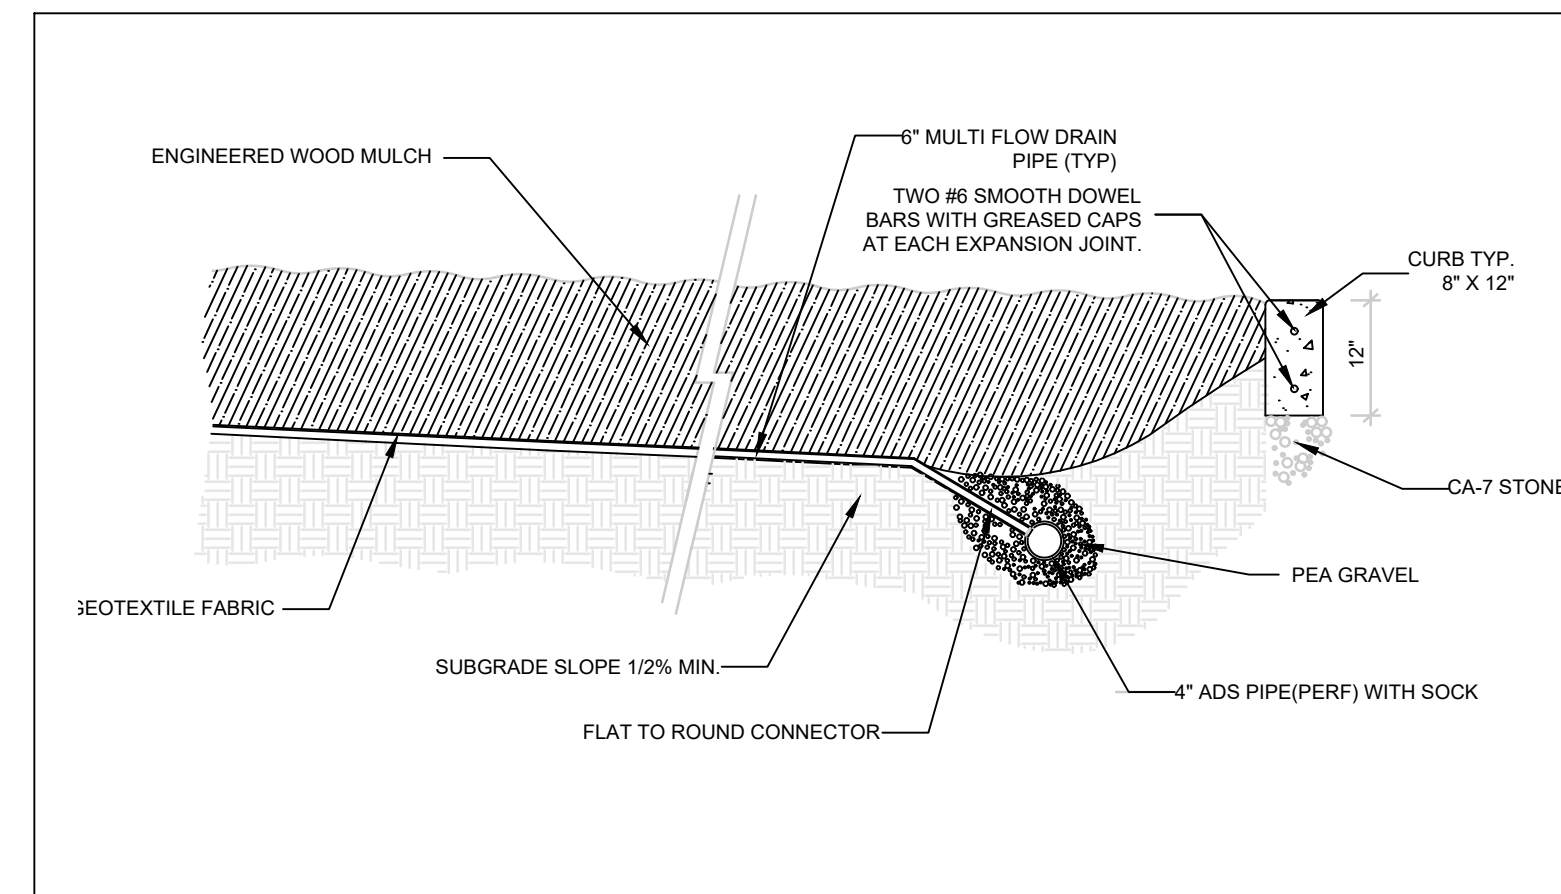


3
4

TYPICAL PLAYGROUND DRAINAGE DETAIL

No Scale

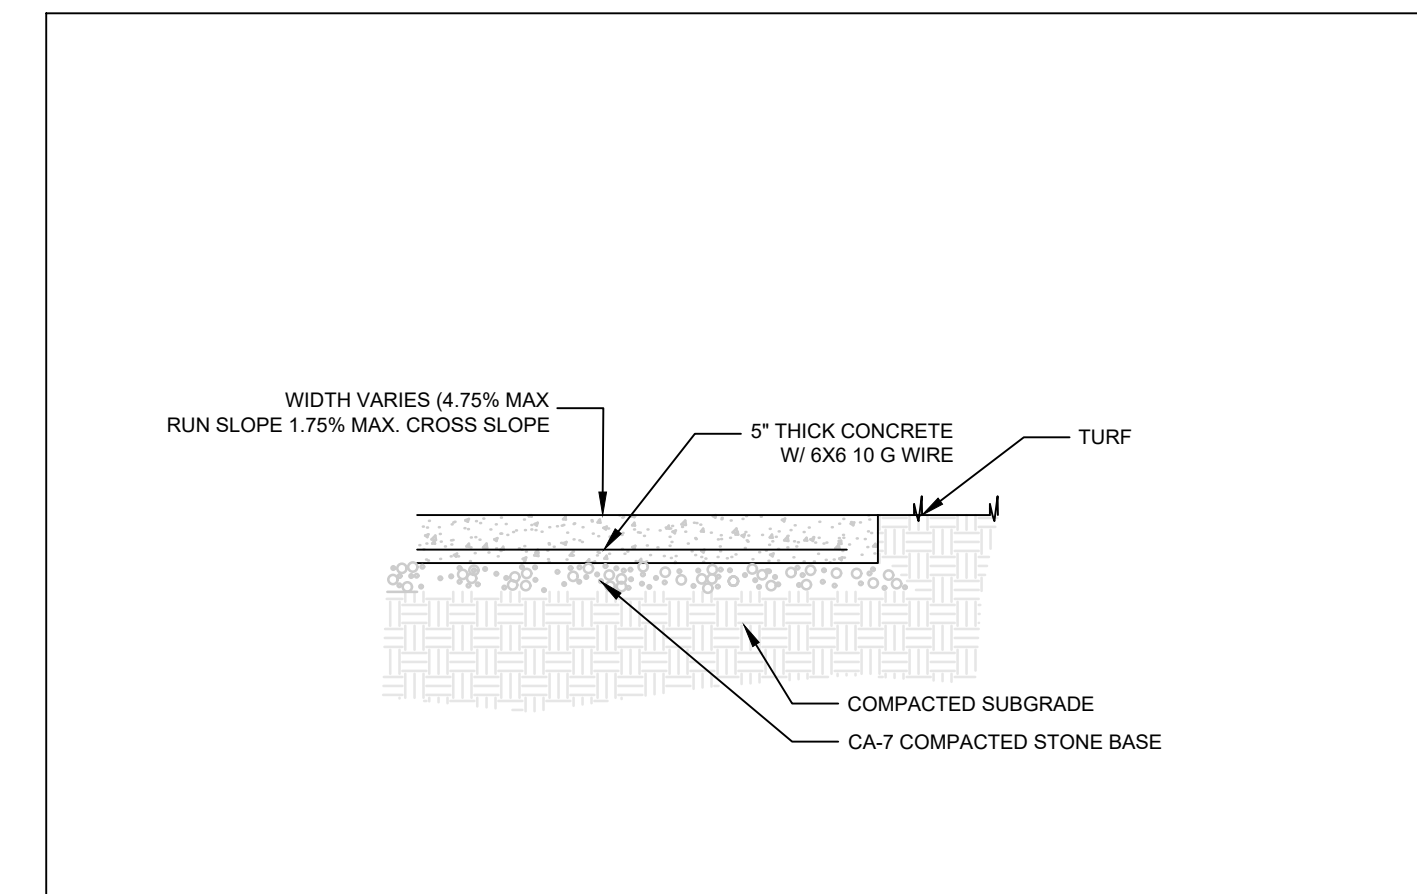


4 CONCRETE SLAB DETAIL
No Scale

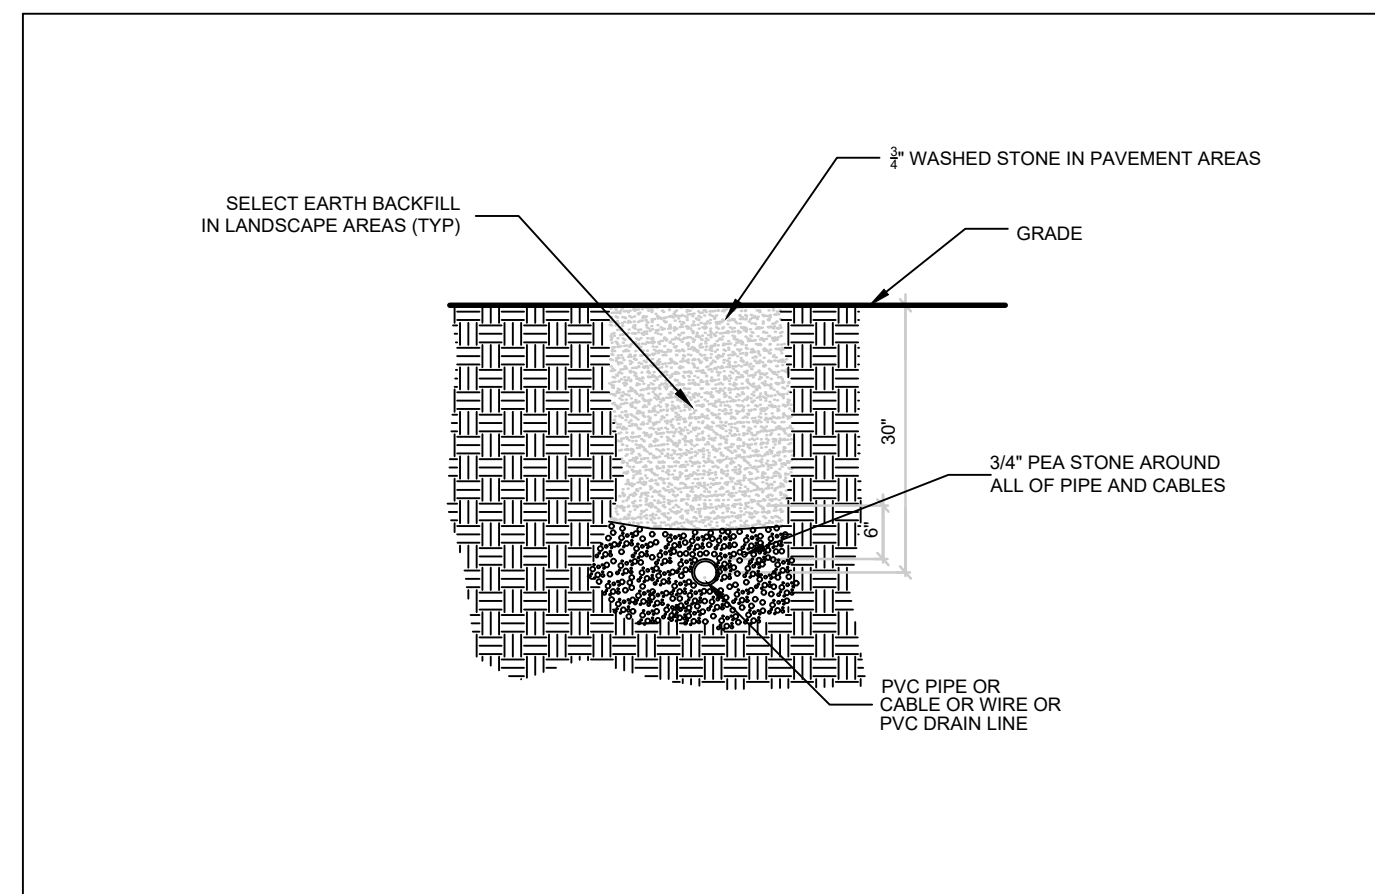


5
4

TRENCH DETAIL

No Scale

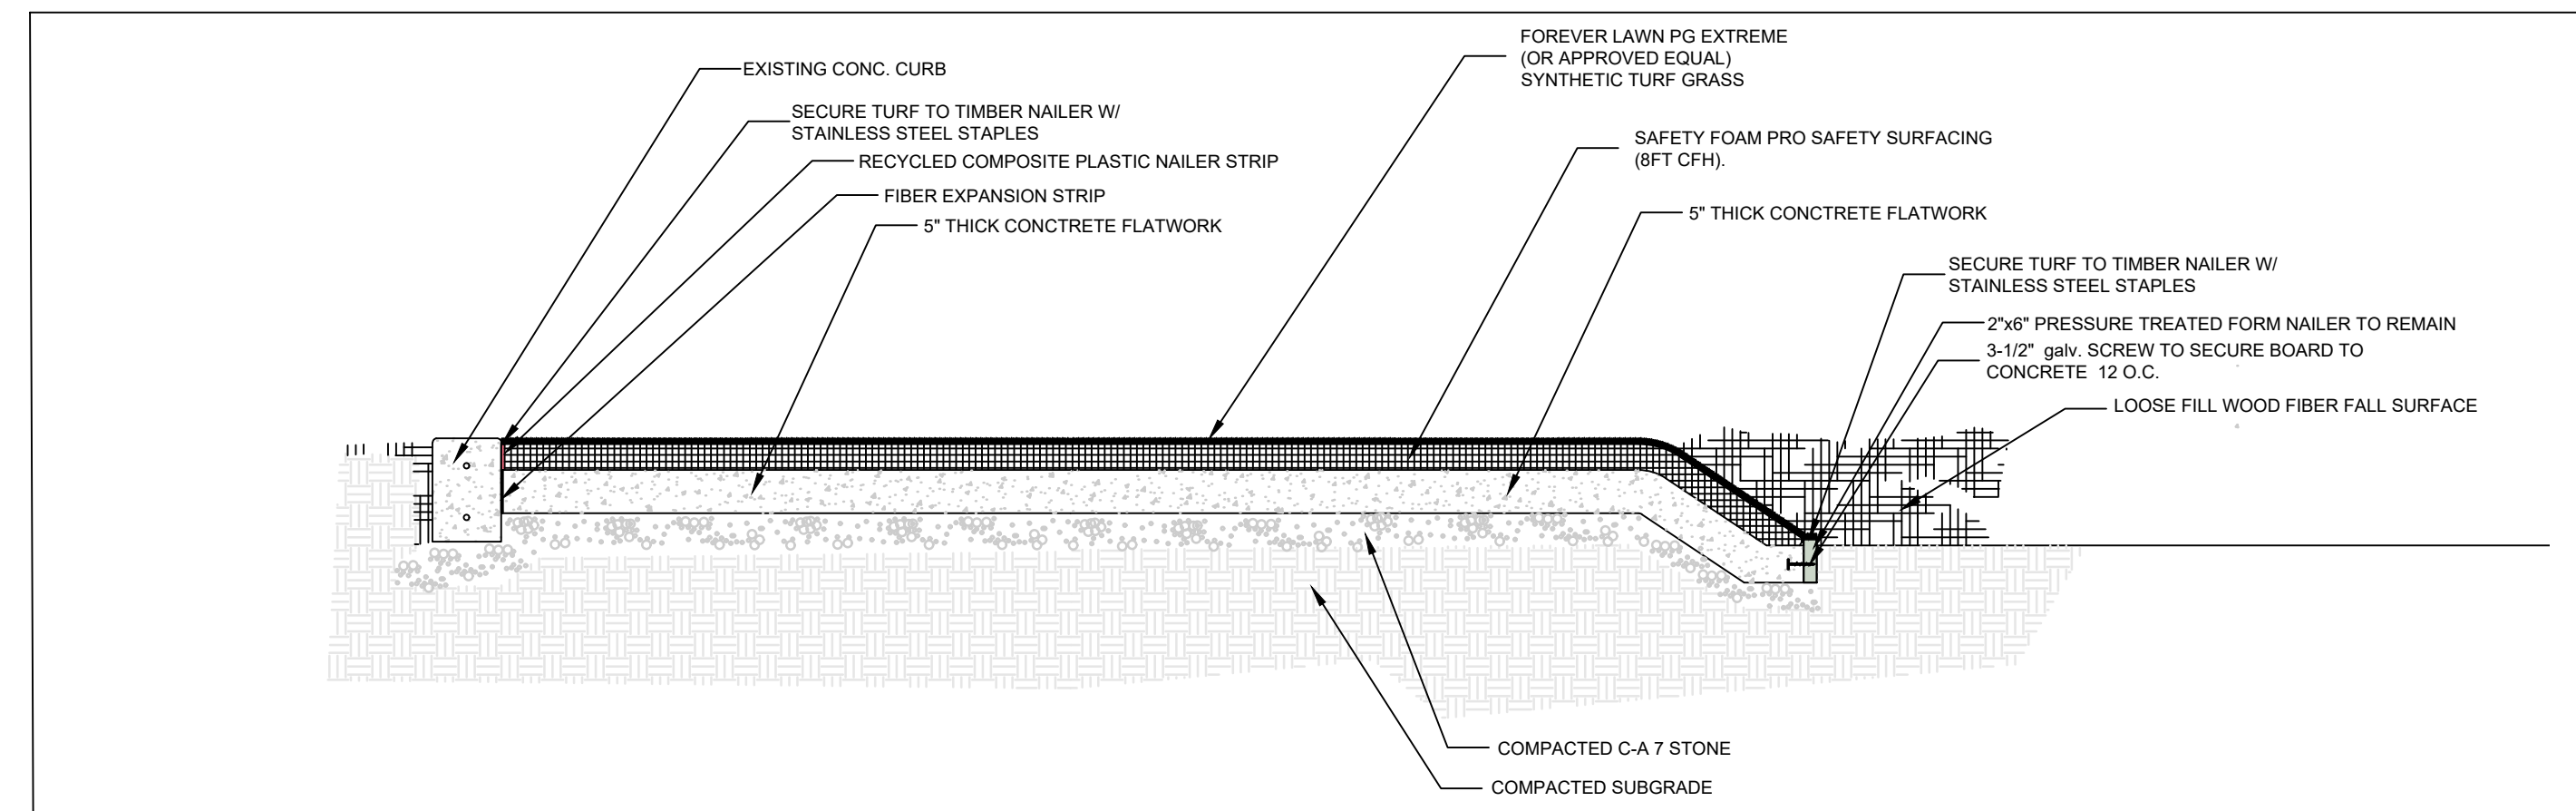


6 SYNTHETIC TURF FALL SURFACE DETAIL

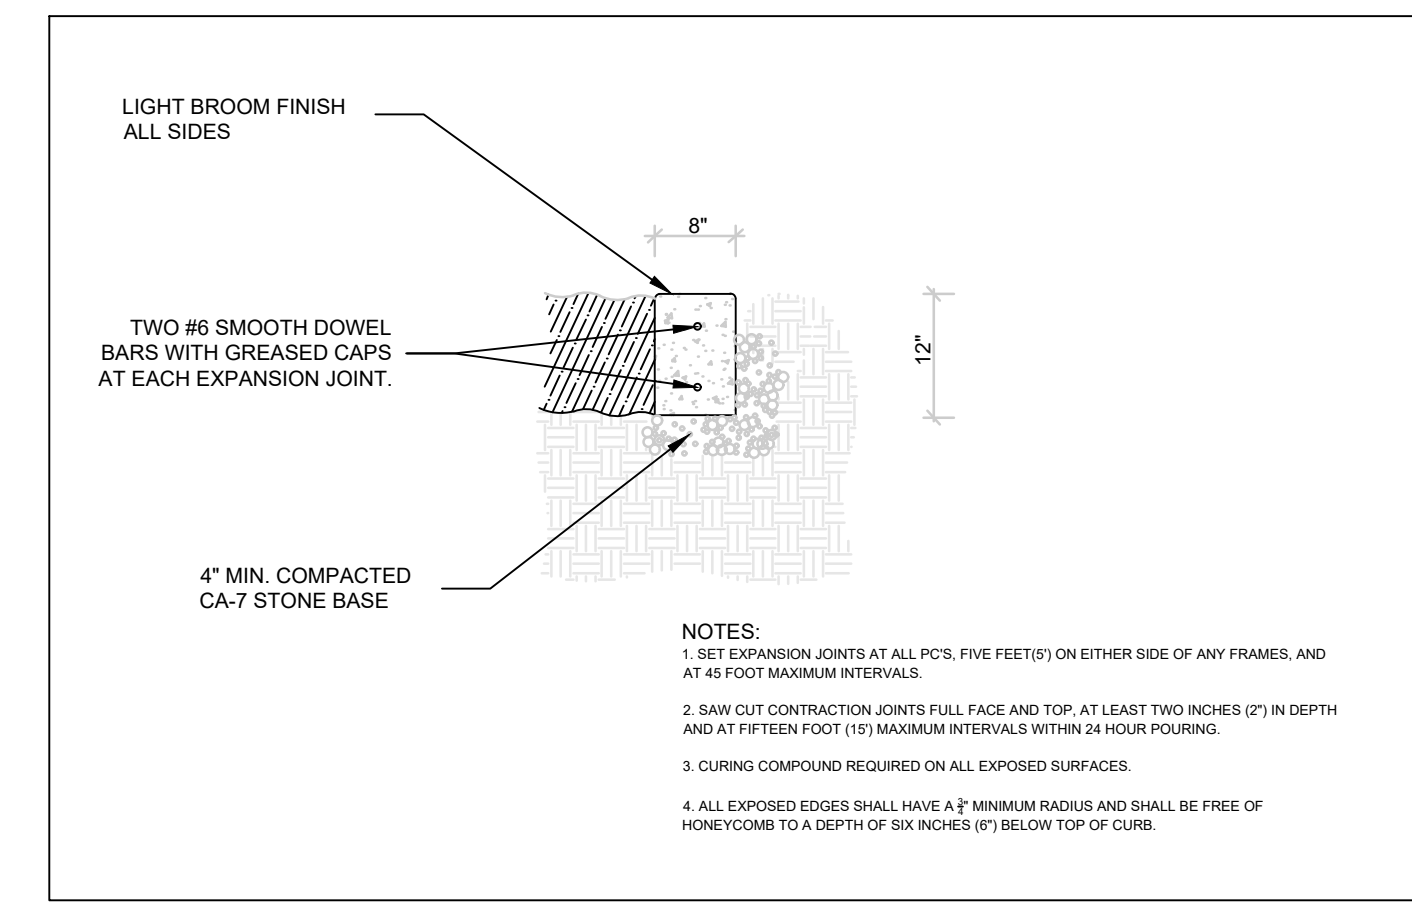

7
4

CURB DETAIL


No Scale

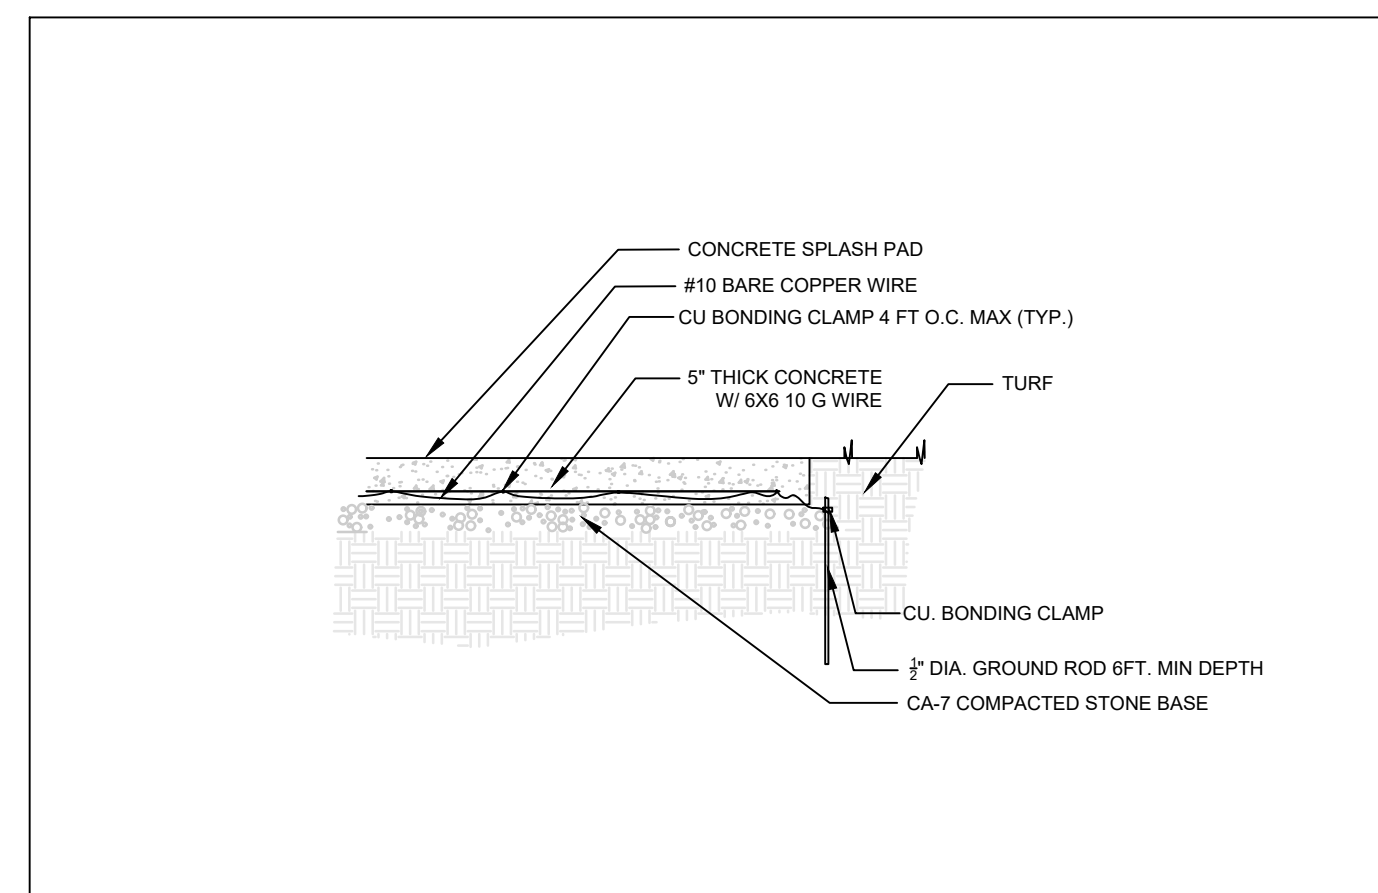

8
4

SPLASH PAD CONCRETE GROUNDING DETAIL

No Scale

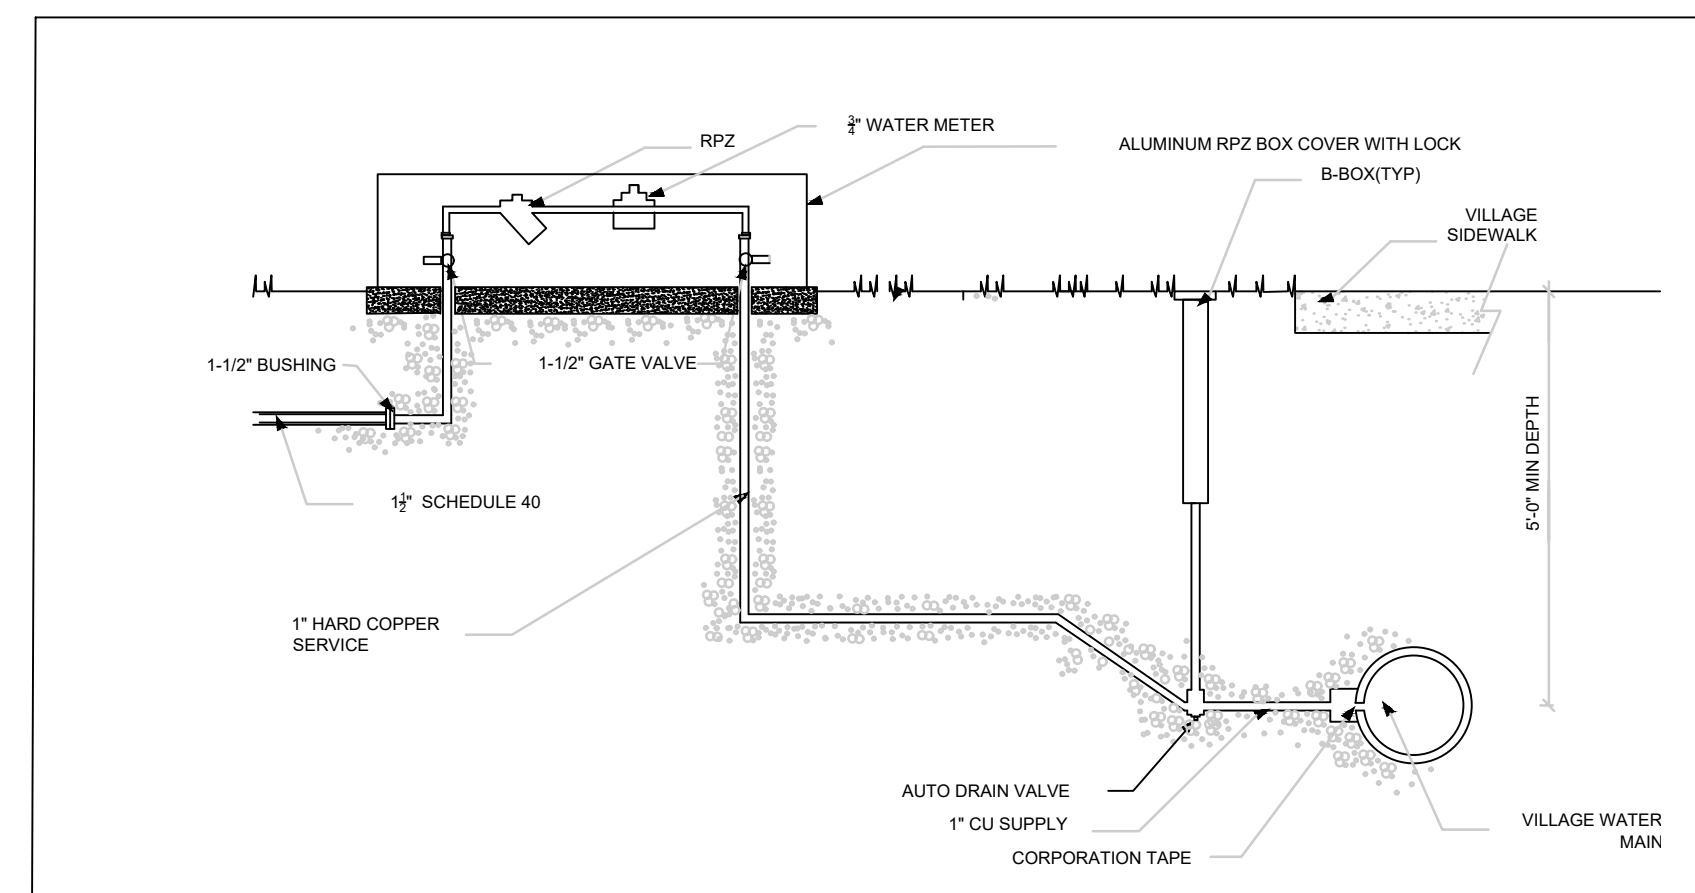

9
4

R.P.Z. WATER LINE DETAIL

No Scale

SCALE AS SHOWN'		4 OF 4	
HOFFMAN ESTATES PARK DISTRICT 1685 WEST HIGGINS ROAD HOFFMAN ESTATES IL: 60169 847-885-7500		PLAYGROUND IMPROVEMENTS 2019 COMMUNITY & WILLOW PARK PLAYGROUNDS	
1	ISSUED FOR REVIEW	2/27/2019	
2	ISSUED FOR BID	3/6/2019	